

ANANIA GEOLOGIC ENGINEERING

April 3, 1990

Ms. Katherine Chesick
Alameda County Health Department
Hazardous Materials Division
80 Swan, Room 200
Oakland, California 95641

SUBJECT: WELL ABANDONMENT


AGE PROJECT No. 004-88-059

Dear Ms. Chesick:

Anania Geologic Engineering (AGE) requests permission to abandon ten more product recovery points at the Carnation Dairy Facility located at 1310 14th Street in Oakland, California. The product recovery points scheduled to be abandoned are PR-8, PR-9, PR-13, PR-14, PR-15, PR-16, PR-92, PR-93, PR-97, and PR-103 and are highlighted on the enclosed map. The wells will be abandoned by over drilling and treming the hole with concrete as specified previously. AGE intends to begin abandoning the wells the week of April 16, 1990. Once AGE receives your approval, a permit from Zone 7 will be obtained.

If you have any questions, please feel free to contact Robyn McKinney at (415) 548-0377 or myself at (916) 631-0154.


Sincerely,
Anania Geologic Engineering

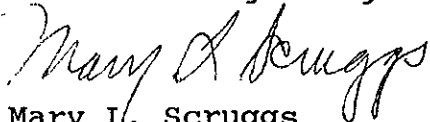

Mary L. Scruggs
Operations Manager
General Partner

Enclosure

cc: Merle Wood
Jim Person

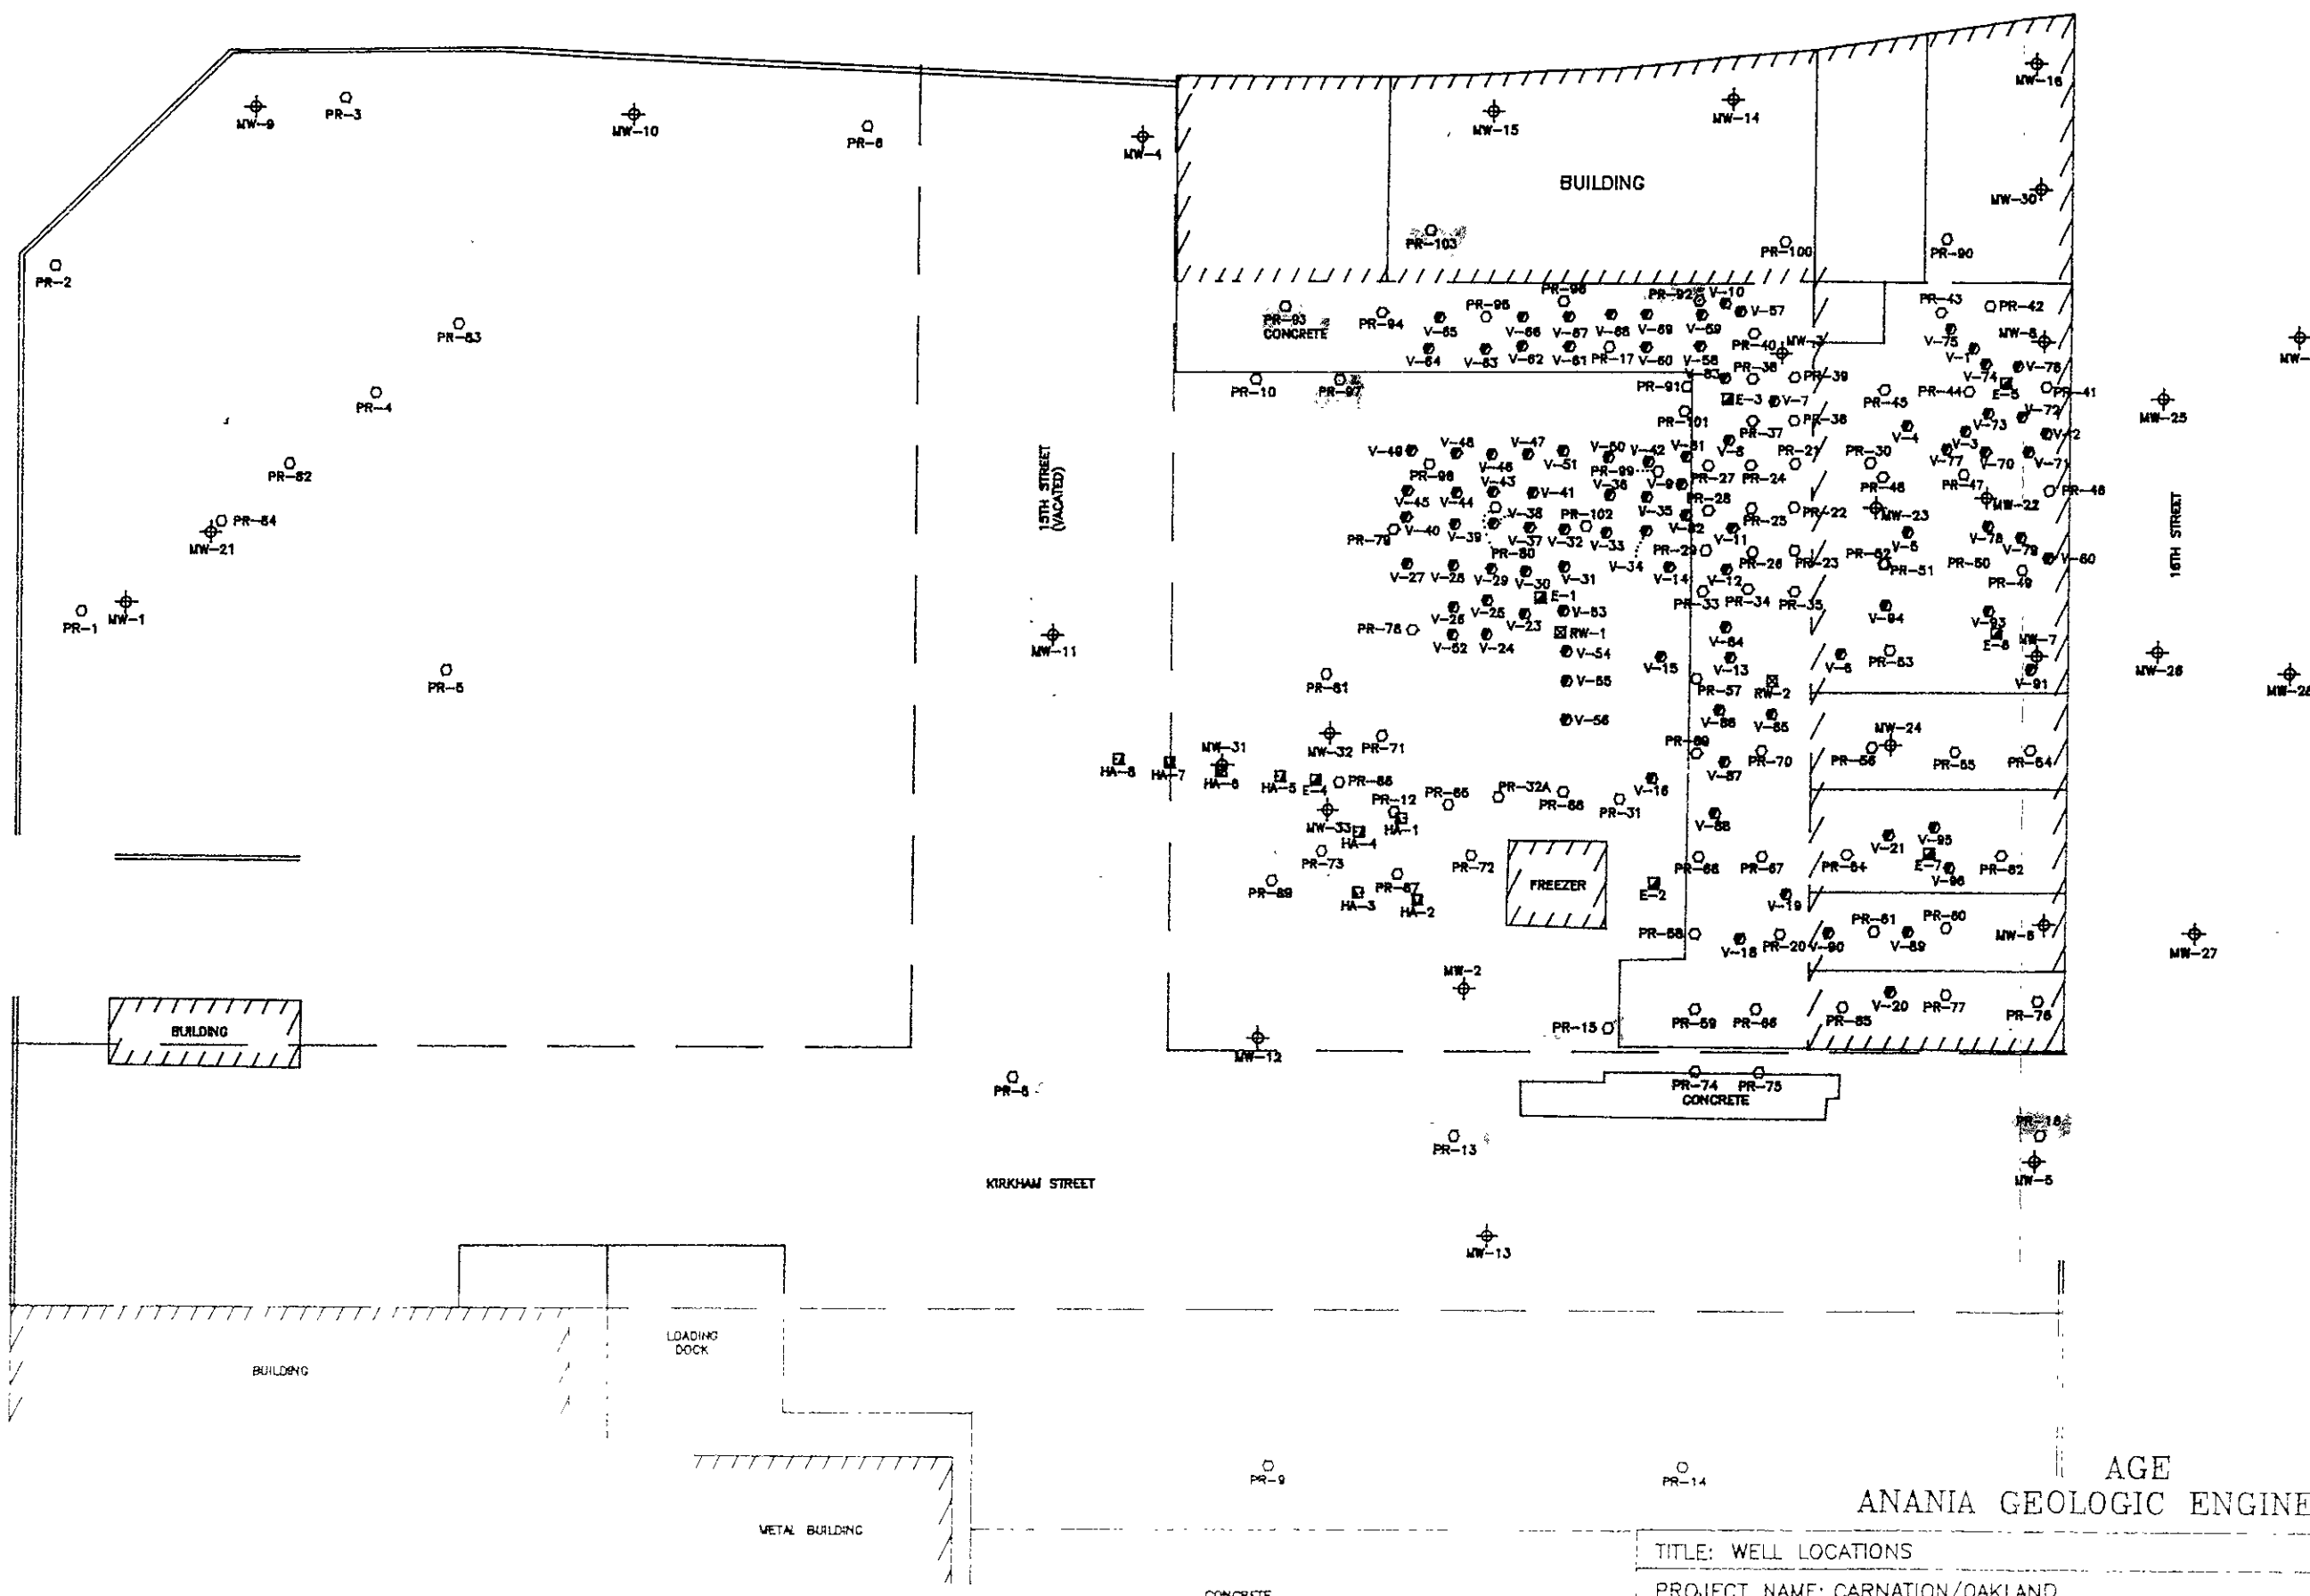

AGE
ANANIA GEOLOGIC ENGINEERING

TITLE: WELL LOCATIONS			
PROJECT NAME: CARNATION/OAKLAND			
SITE LOCATION: 1310 14TH STREET, OAKLAND, CA			
DATE: 3/29/90	DRAWING NO.: 059-201	SCALE: 1" = 40'	PROJECT NO.: 004-88-059