
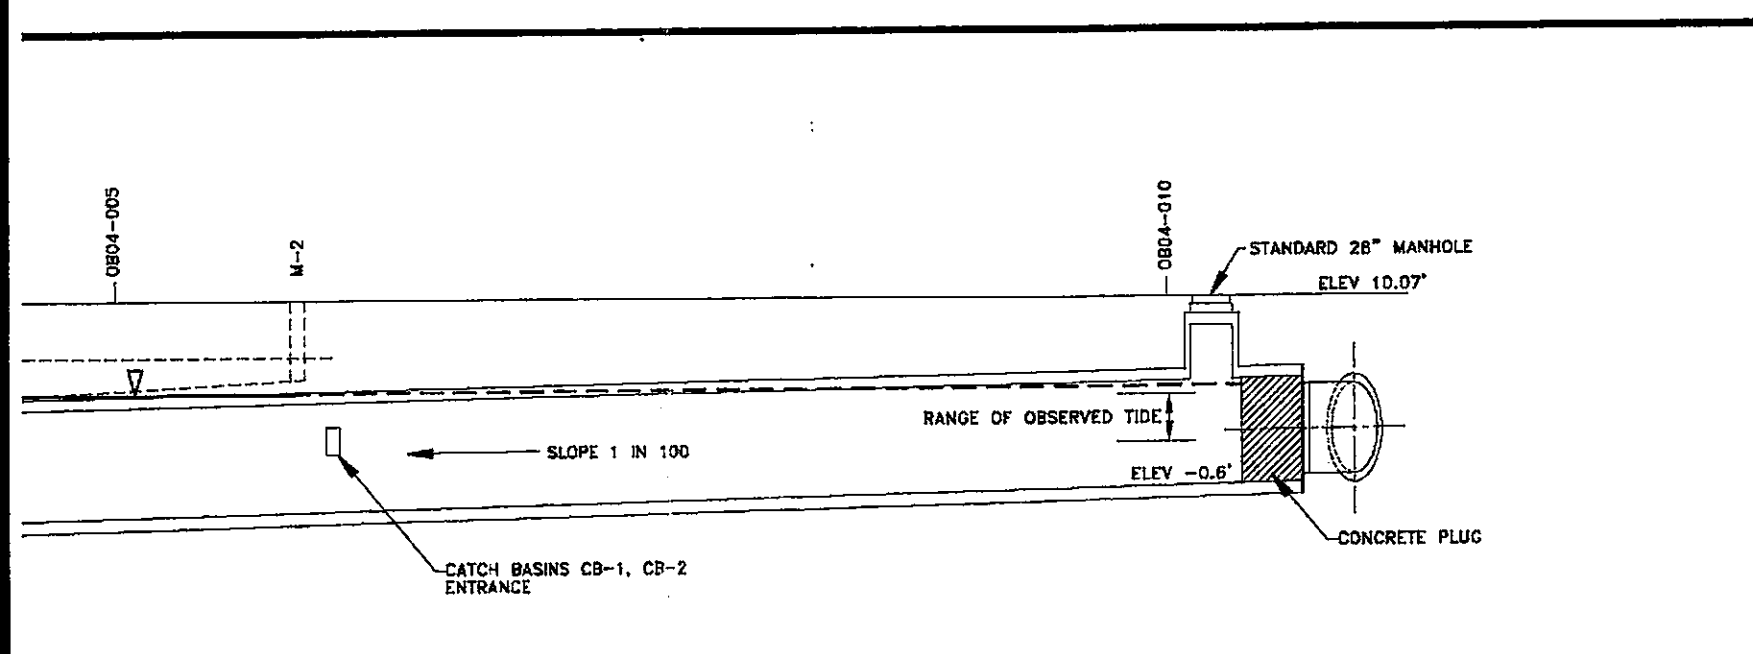


NOTES:  
 1. TIDE ELEVATIONS CORRECTED TO USGS DATUM.

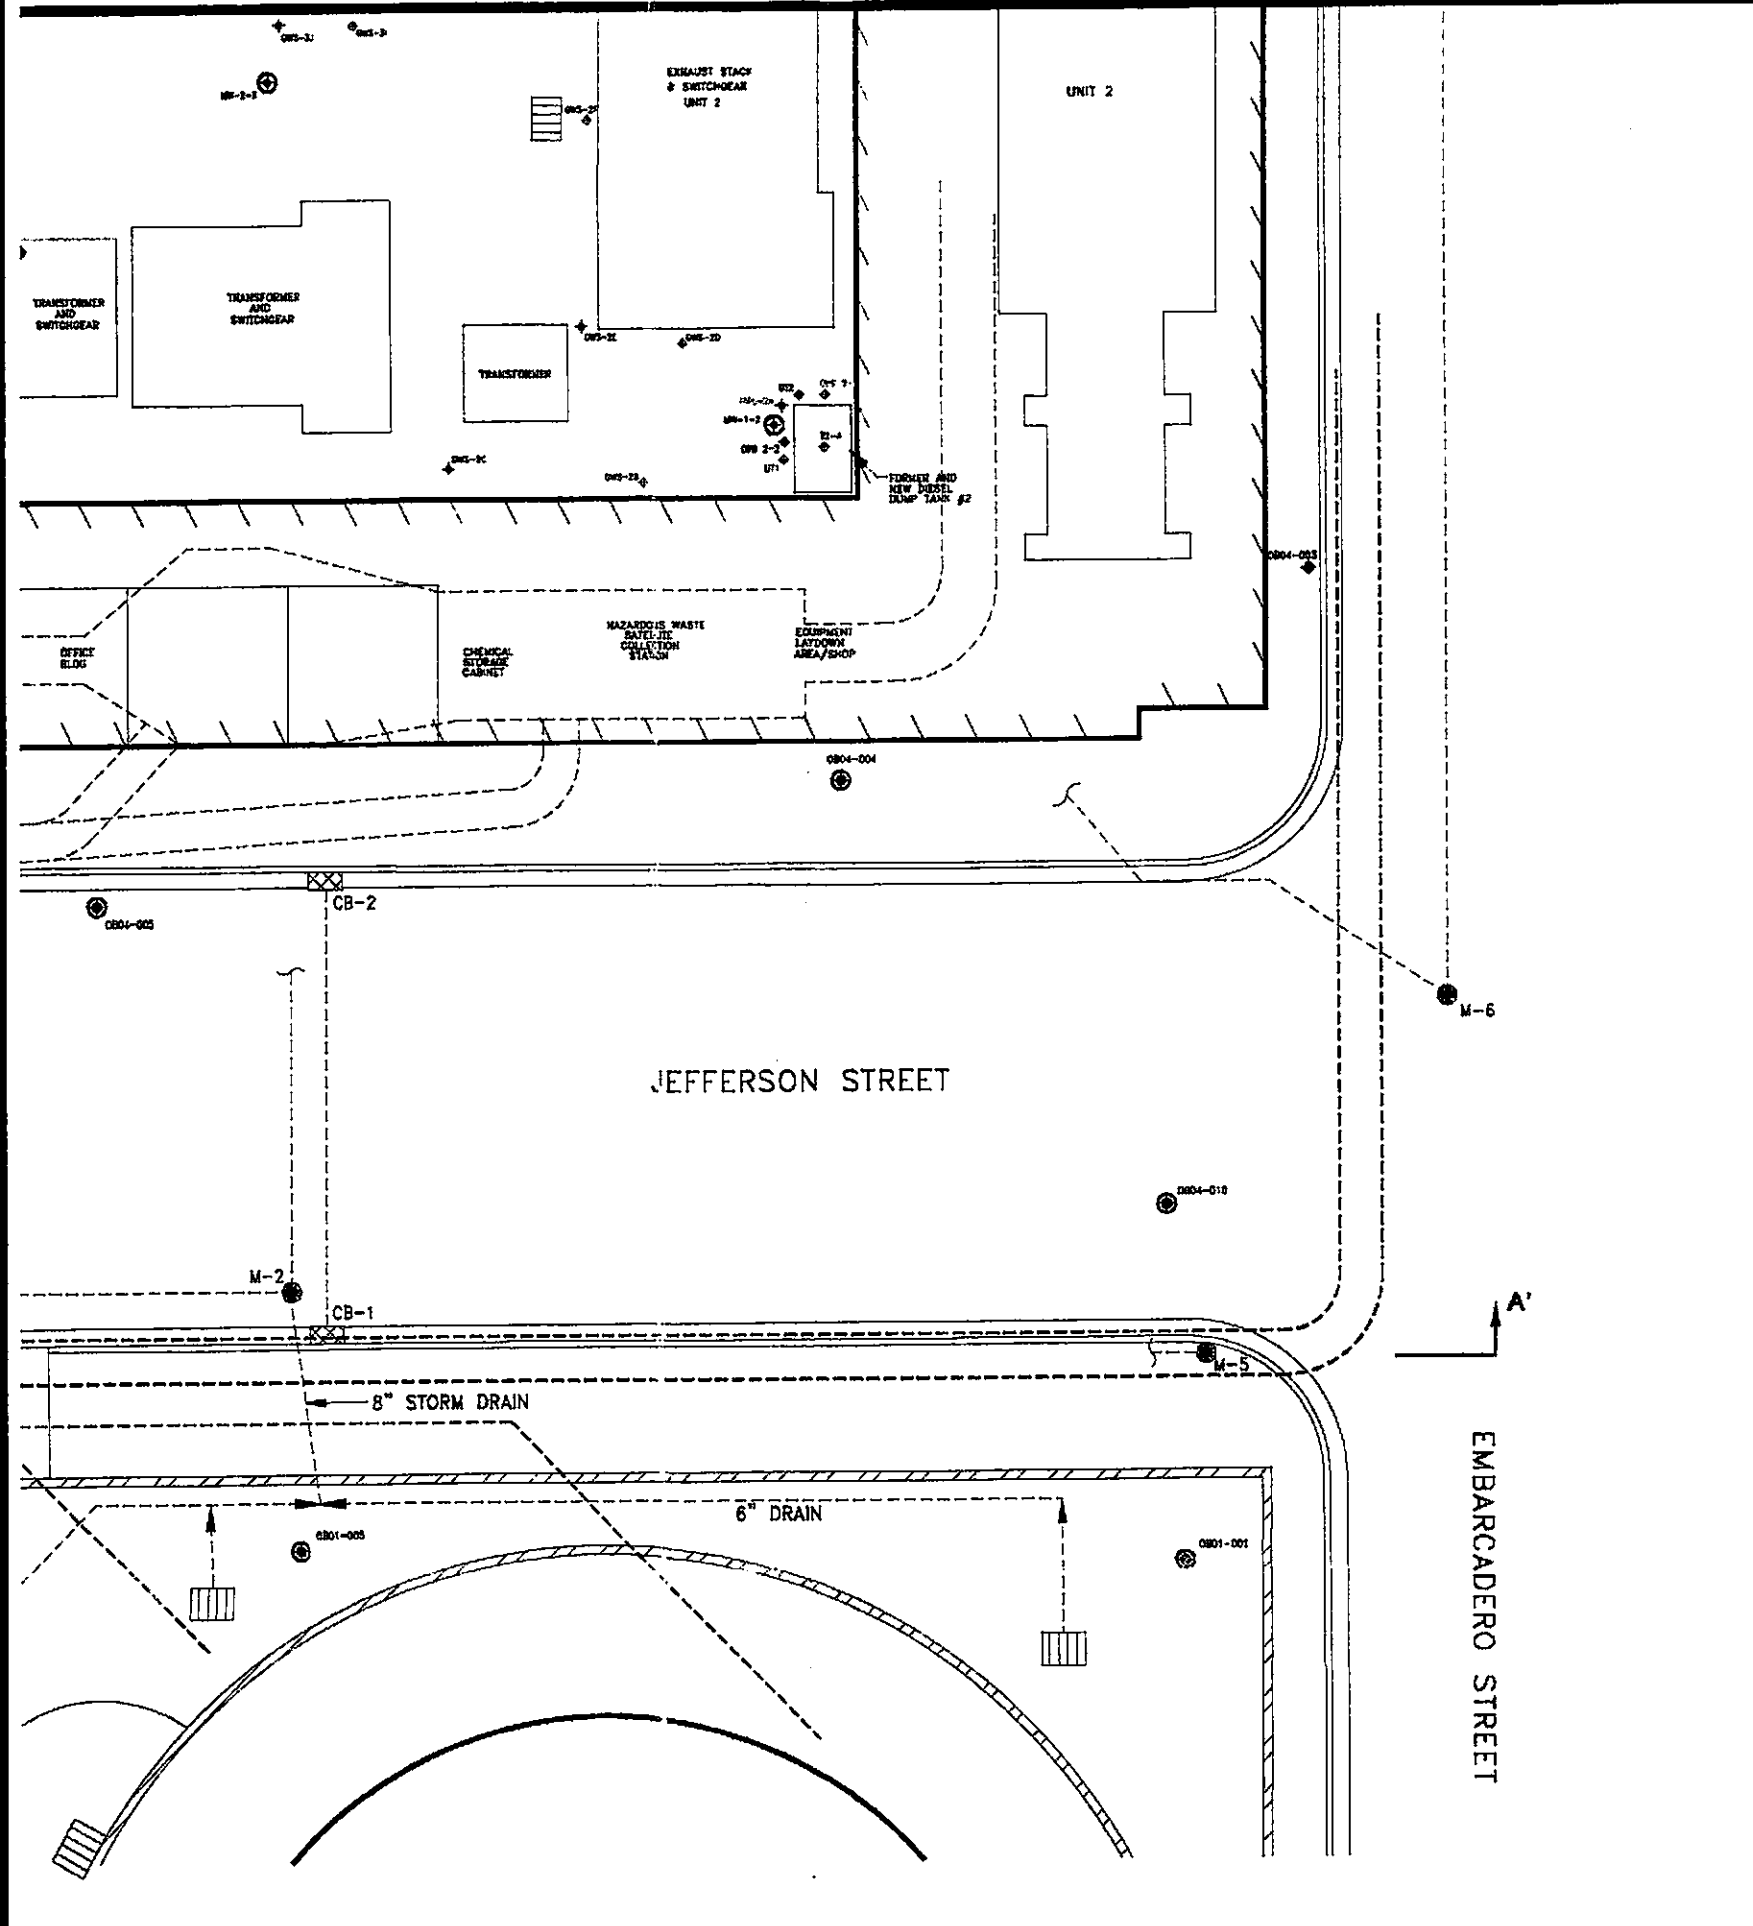

DRAWING NO.	INITIAL DATE	USED FOR
31923	1915	FORMER 8" CR. LINE
38858	1920	PIPE TRENCH, 2" CITY WATER LINE AND 10" STEAM LINE
40381	1912	DISCHARGE DUCT AND INTAKE DUCT
42281	1921	PIPE TRENCH
43828	1927	DISCHARGE DUCT WATER SEAL, AUXILIARY INTAKE DUCT
200710	1957	REMOVAL OF PLUG IN DISCHARGE DUCT
416859	1954	PIPE TRENCH, DISCHARGE FROM MANHOLES M-1 AND M-2
456438 456439	1976	PIPE TRENCH
456646	1975	8" SEWER AND MG LINES

**FLUOR DANIEL GTI**

**PACIFIC GAS AND ELECTRIC COMPANY**

OAKLAND POWER PLANT  
 OAKLAND, CALIFORNIA

**PHASE II ENVIRONMENTAL SITE ASSESSMENT  
 DETAILS OF ANTHROPOGENIC STRUCTURES ALONG  
 JEFFERSON STREET**

DESIGNED BY: DRAWN BY: CHECKED BY:  
 ML  
 DATE: 2/27/97 FILE: F3-4  
 PROJECT NO.: 020200238 CONTRACT:

DRAWING: **3-4**