

(510) 429-8088
(800) 523-8088
FAX (510) 429-8089



Of Northern California, Inc.

FROM: TANK PROTECT ENGINEERING

DATE: 6/3/93

TO: ALAMEDA CO HEALTH

ATTN: BARNEY CHAN

RE.: _____

NO. OF PAGES: 5
(Include cover sheet)

If all pages are not received please notify sender.

MESSAGE:

PER OUR CONVERSATION TODAY, I AM FAXING YOU 2 SITE PLANS (FIESTA BEVERAGES & MANUEL RODRIGUES) SHOWING PROPOSED MONITORING WELL LOCATIONS. THESE LOCATIONS UPDATE THOSE SHOWN ON TIE'S WORKPLANS FOR EACH SITE. THESE NEW LOCATIONS ARE BASED ON 2 GRADIENT DETERMINATIONS MADE FOR LANAI DOR AT 925 89TH AVE. I HAVE INCLUDED THE LANAI DOR GRADEWATER MAP FOR 4/20/92; THE MOST RECENT GRADIENT OF 8/92 WAS VERBALLY GIVEN TO ME BY CRAIG DALZIN WITH BYMYER AS NNW. I AM ALSO FAXING YOU A THOMAS BROS. MAP SHOWING APPROXIMATE RELATIVE LOCATION OF THE 3 SITES.


PLEASE LET ME KNOW IF YOU APPROVE THE NEW LOCATIONS.

JOHN MADAKOVICH

FOR CONTINUATION SEE MAP 12

1" = 1100'

22

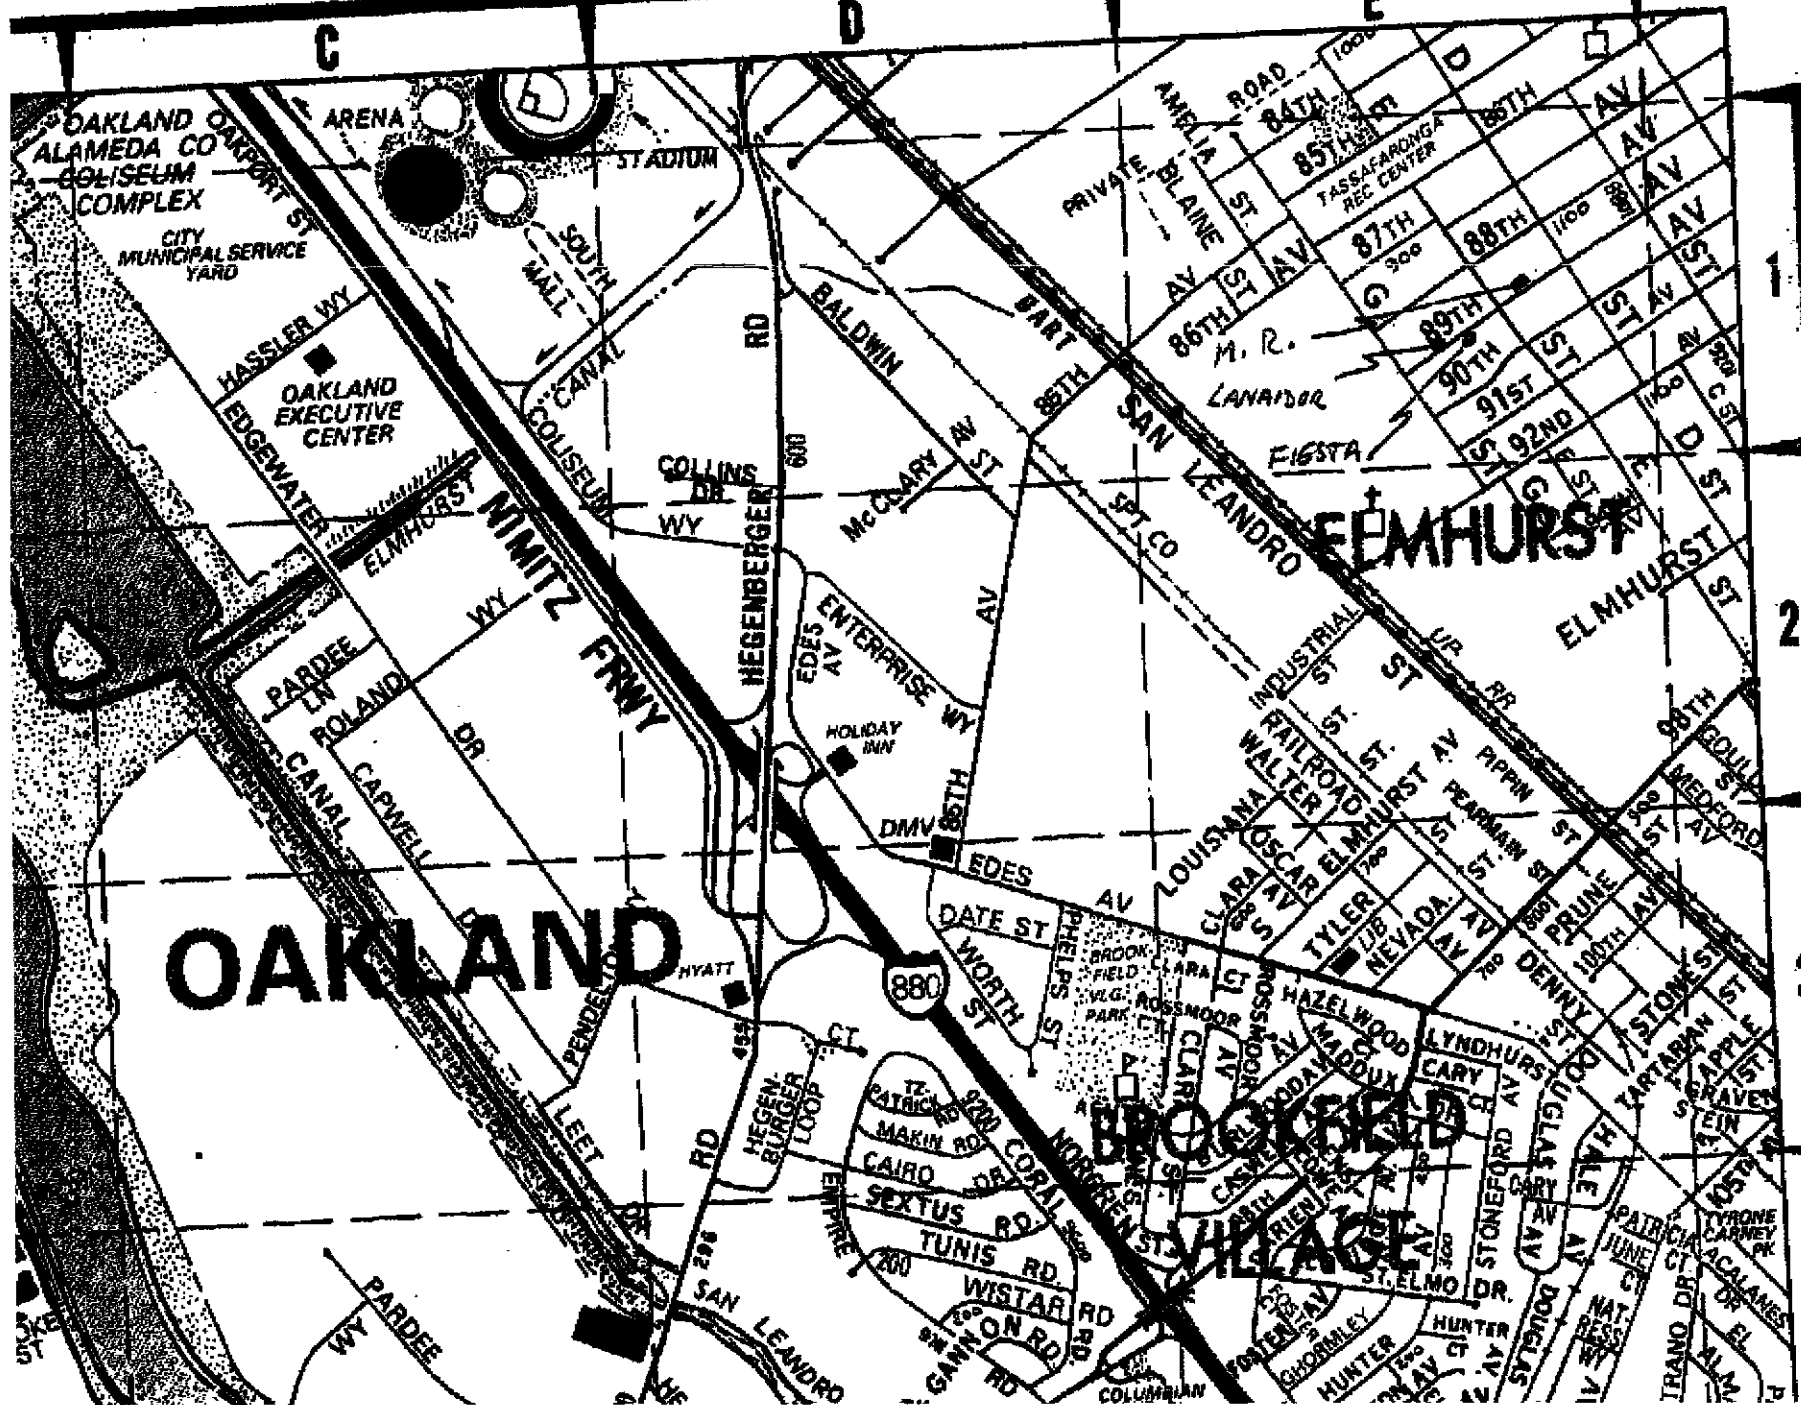

COPYRIGHT 1990 BY Thomas Donner Map

25


CONTINUATION SEE MAP



0 15 30
SCALE IN FEET
(APPROXIMATE)

*Gradient
8/92 NNW - Craig Dirgin*

G STREET

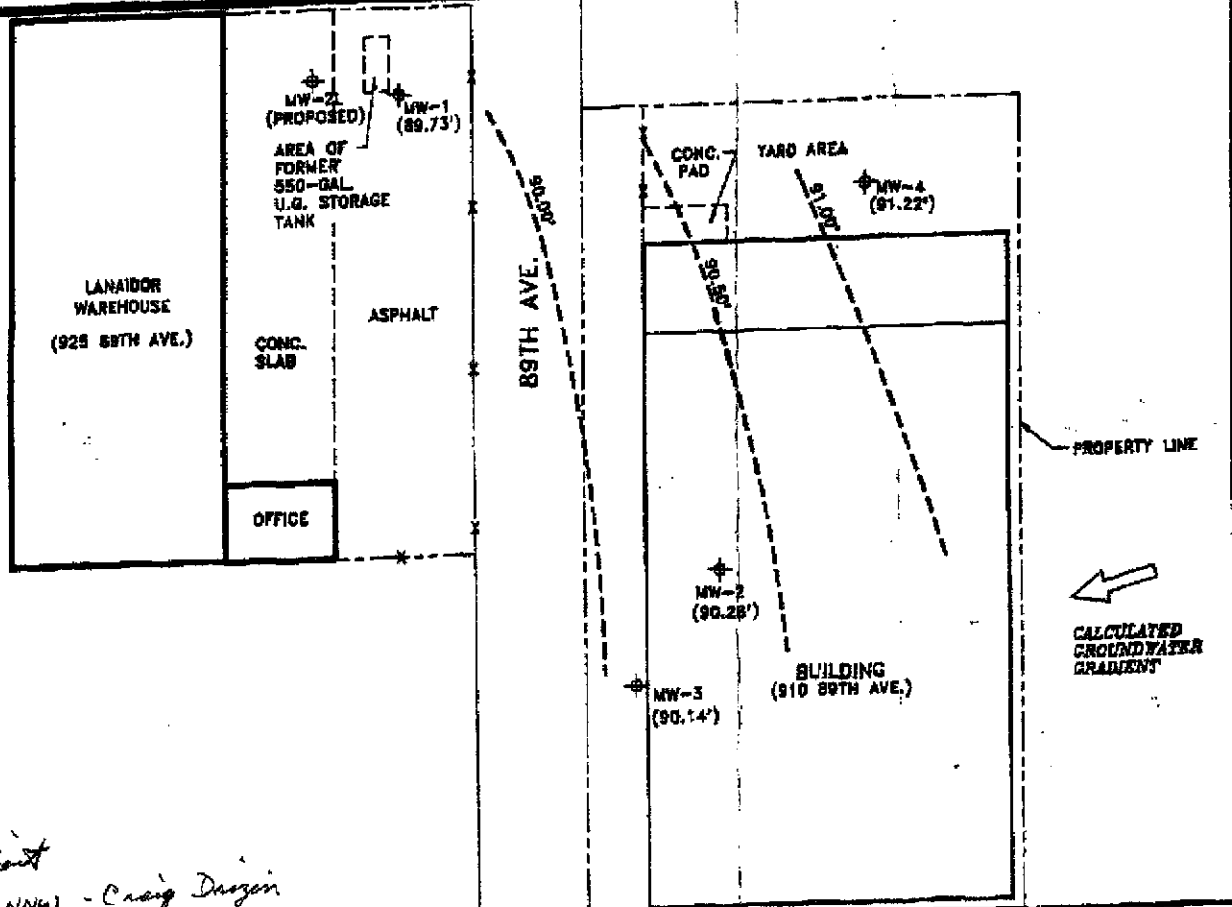

BLUMBERG
ENGINEERS, INC.


REG. JOB NO.
91175

DATE
5/92

LEGEND
 MONITORING WELL
 (90.28') GROUNDWATER
 ELEVATION

PROJECT
 LANAIDOR, INC.
 OAKLAND, CA
 GROUNDWATER GRADIENT
 4/20/92 WELLS
 MW 1, 2, 3, 4

FIGURE
4

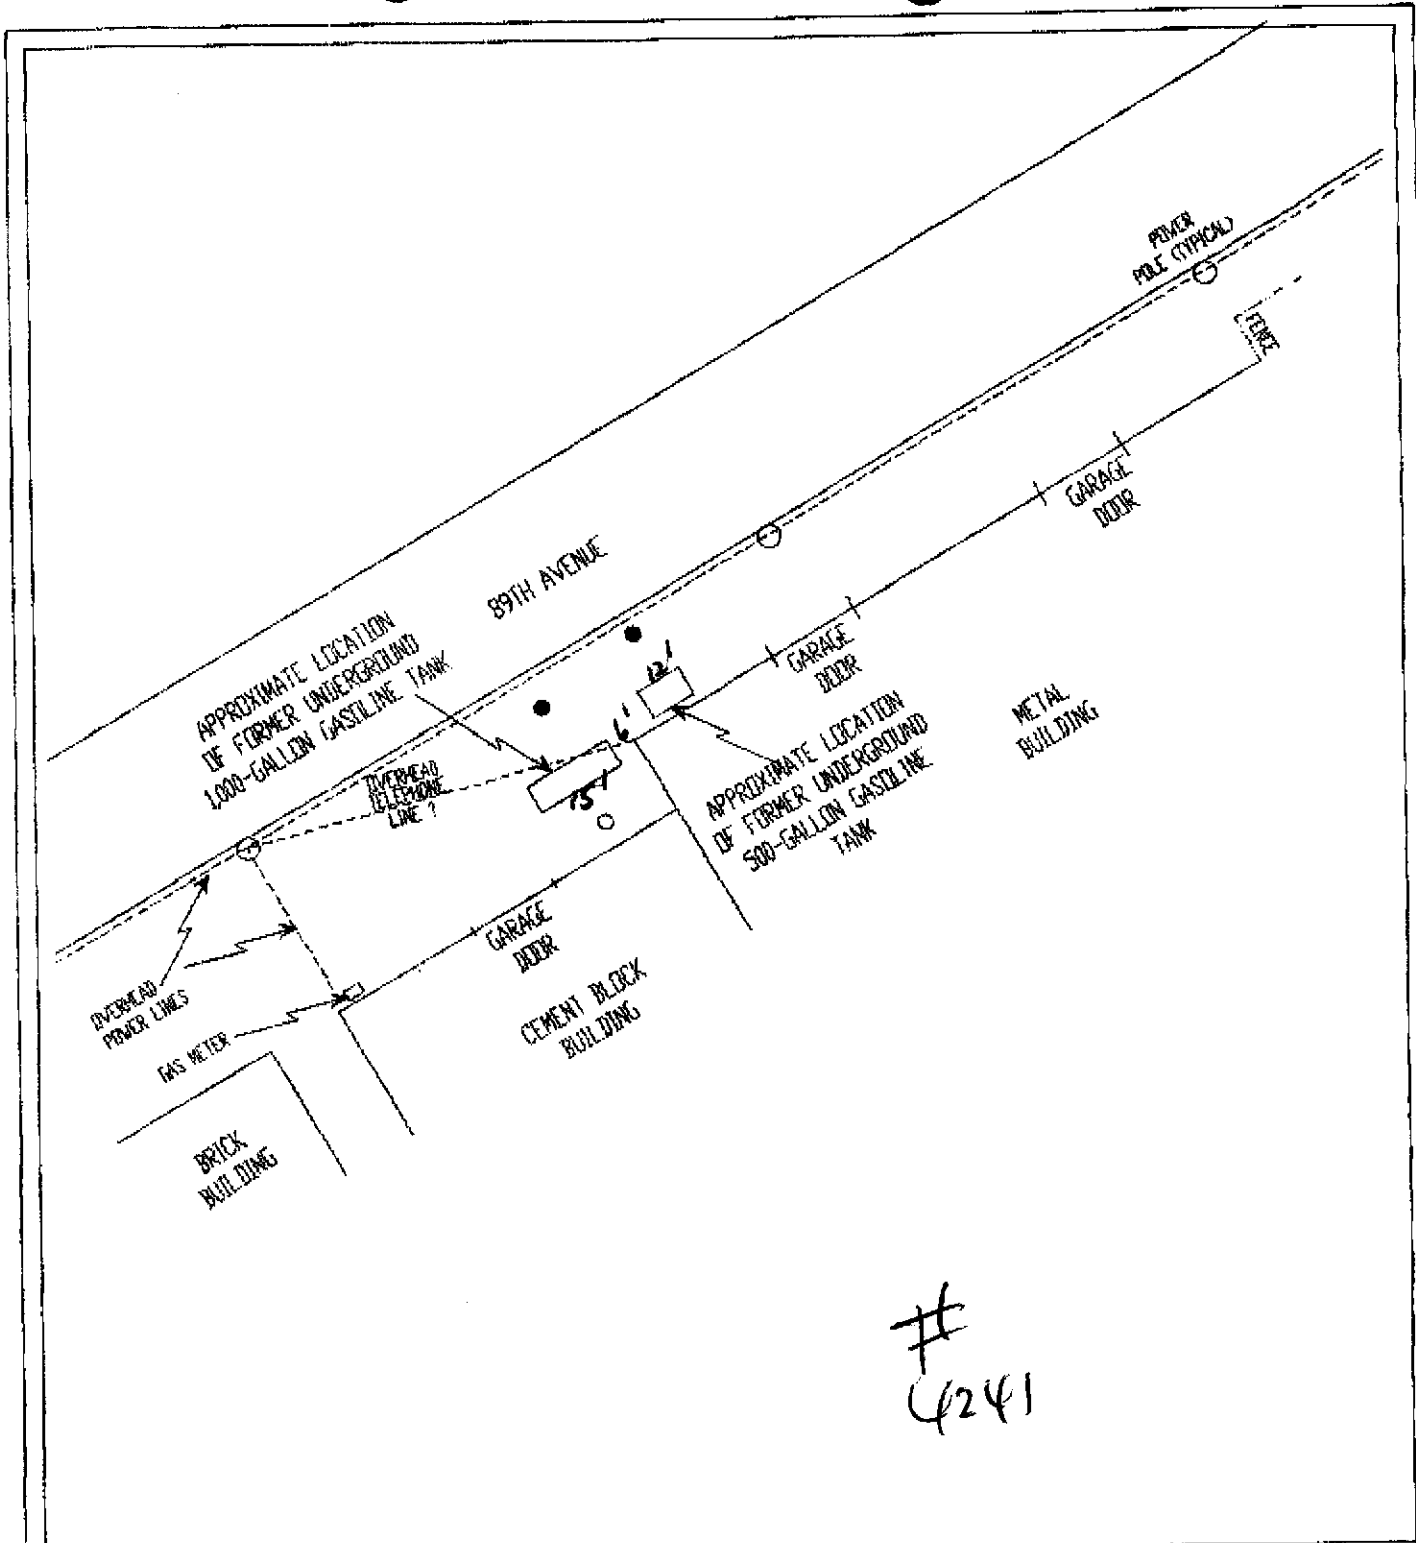

4241

LEGEND


- PROPOSED LOCATION OF GROUNDWATER MONITORING WELL
- PROPOSED LOCATION OF SOIL BORING

0 25
SCALE IN FEET

TANK PROTECT ENGINEERING

SITE PLAN

FIESTA BEVERAGES 966 89TH AVENUE OAKLAND, CA 94621	<table border="1" style="width: 100%; border-collapse: collapse;"> <tr> <td style="width: 30%;">DATE</td> <td>6/2/93</td> </tr> <tr> <td>FIGURE</td> <td></td> </tr> <tr> <td>FILE #</td> <td>264-2-7</td> </tr> <tr> <td>DRAWN BY</td> <td>SL</td> </tr> <tr> <td>CHECKED BY</td> <td>JVM</td> </tr> </table>	DATE	6/2/93	FIGURE		FILE #	264-2-7	DRAWN BY	SL	CHECKED BY	JVM
DATE	6/2/93										
FIGURE											
FILE #	264-2-7										
DRAWN BY	SL										
CHECKED BY	JVM										

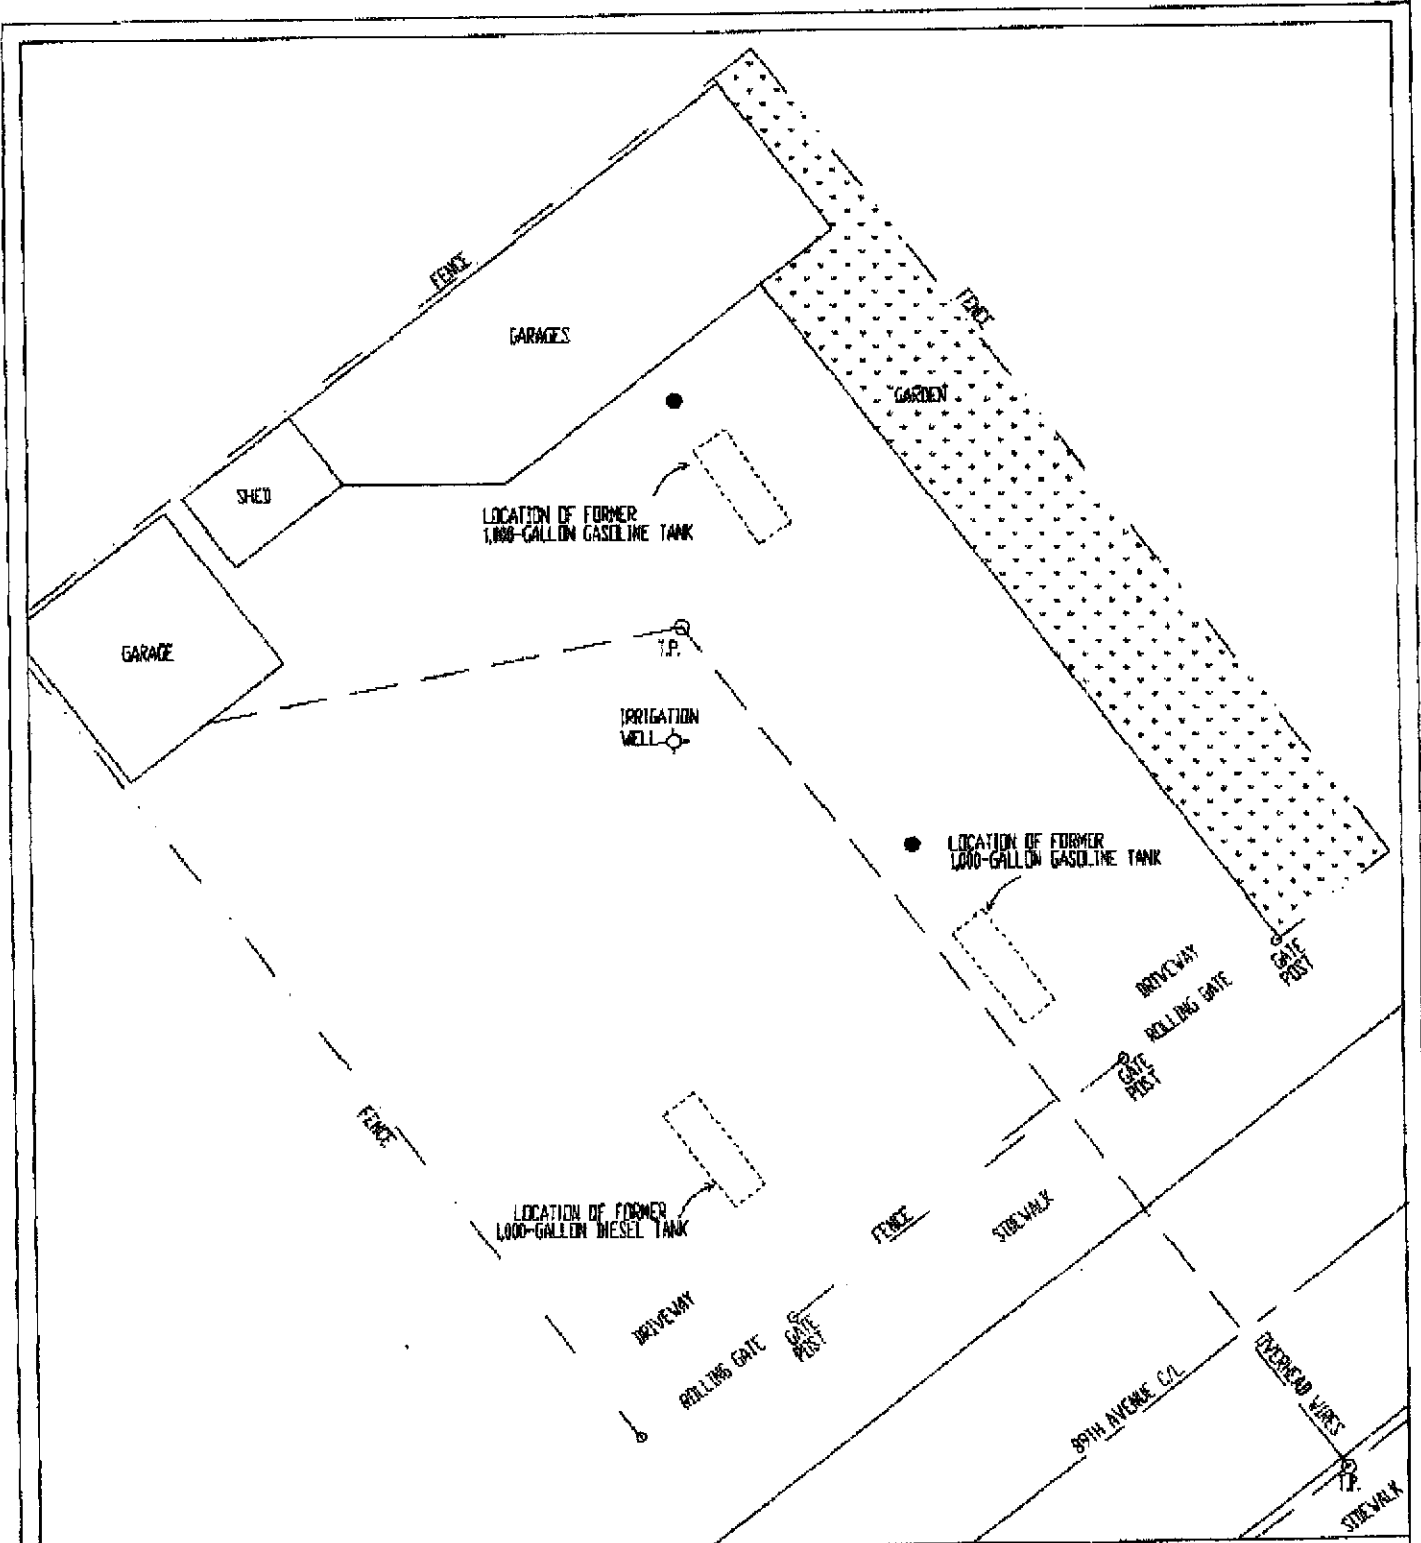

LEGEND

- PROPOSED LOCATION OF GROUNDWATER MONITORING WELL
- T.P. LOCATION OF TELEPHONE POLE



0 20
SCALE IN FEET

TANK PROTECT ENGINEERING

SITE PLAN

MANUEL RODRIGUES
1009 89TH AVENUE
OAKLAND, CA

DATE	6/3/93
FIGURE	
FILE #	225C-7-1
DRAWN BY	MAC
CHECKED BY	JVM