

MONTGOMERY  
WARD  
AUTO CENTER

SANWA  
BANK

CARROWS  
RESTAURANT

CROWN  
CHEVROLET  
PROPERTY

ENE  
PARCEL 1

AMADOR

DUBLIN BLVD.

GOLDEN GATE DRIVE

Treatment  
System

FORMER LOCATION OF USTs

SIDEWALK

SIDEWALK


CONCRETE PAD

ENE


EXPLANATION:

- ⊕ ADS GROUND WATER MONITORING WELL
- ⊕ EAI GROUND WATER MONITORING WELL
- ⊗ HLA GROUND WATER MONITORING WELL
- EPIGENE GROUND WATER MONITORING WELL
- CYPRESS GROUND WATER MONITORING WELL
- EAI CPT LOCATION
- ⊠ EAI CPT HYDROPUNCH LOCATION
- ⊕ EAI HYDROPUNCH LOCATION
- ⊙ EPIGENE HYDROPUNCH
- ⊕ PROPOSED SENTINAL WELL LOCATION

- All wells surveyed to the city of Dublin Benchmark No DUB-680 (elevation = 331.60 feet MSL)

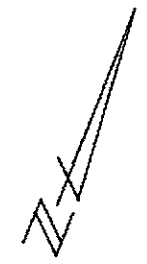

DUBLIN BLVD.

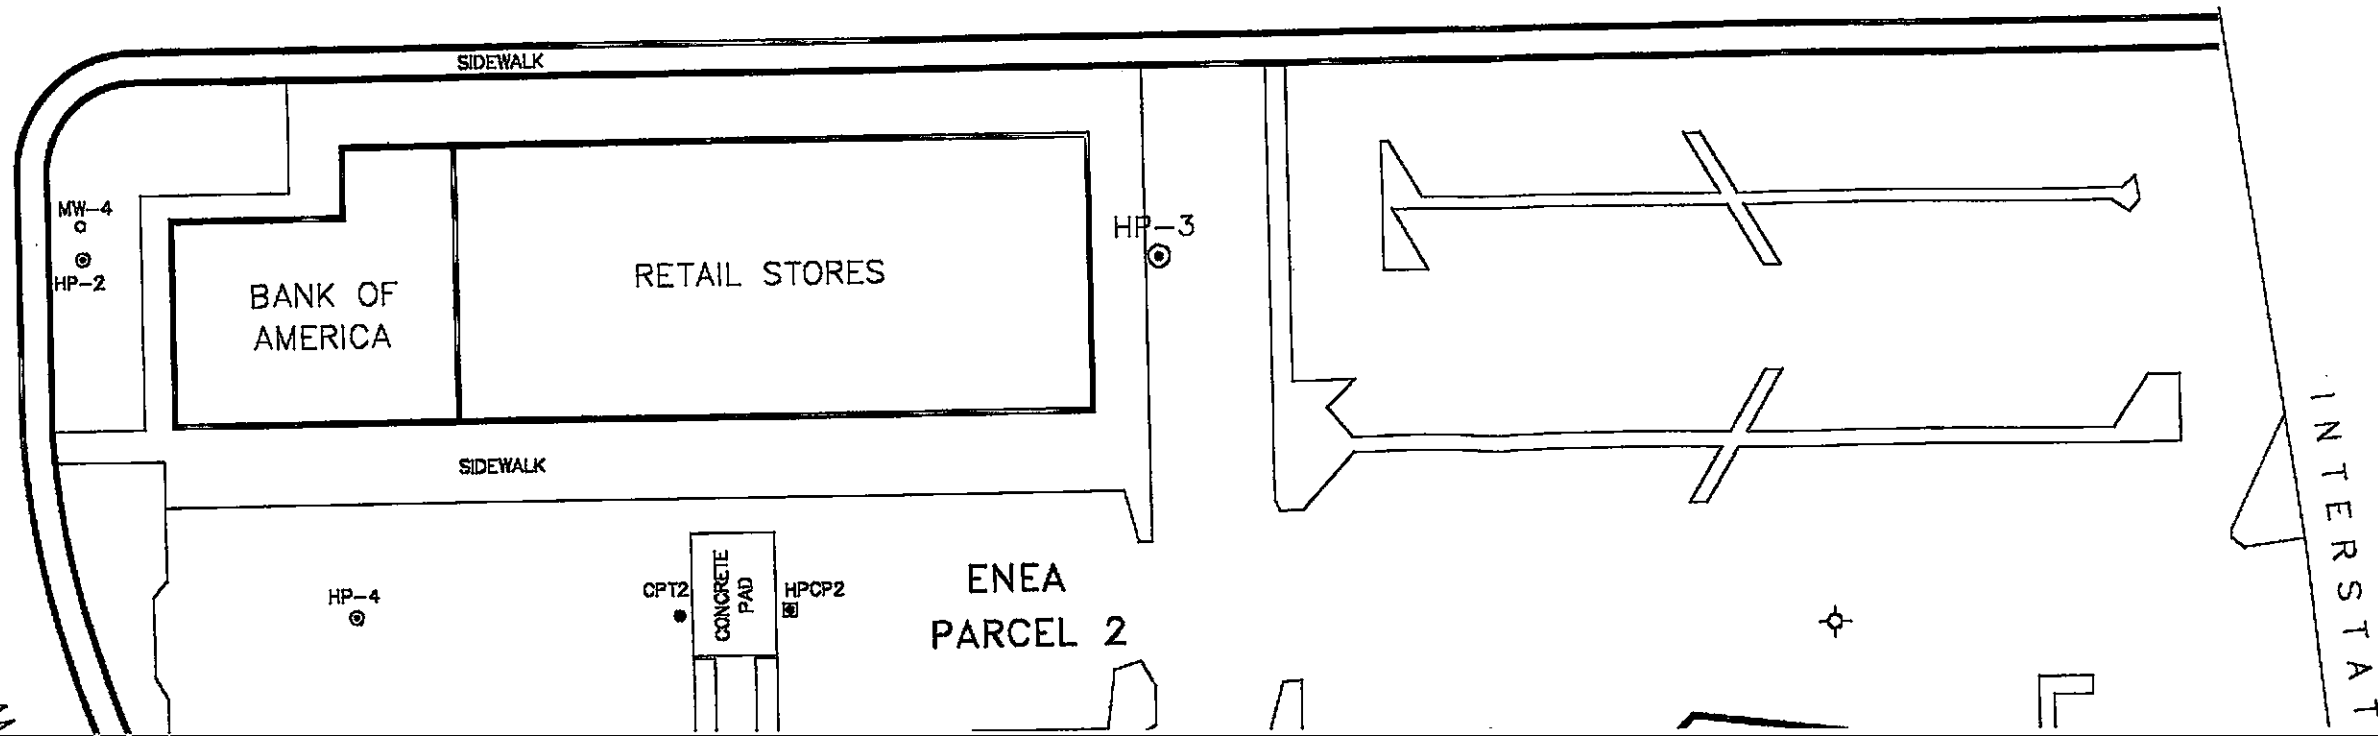

OFFICE



 


SERVICE DEPT.


HP-1  
⊙

MW-2  
⊙

0 50'  
APPROX. SCALE

Job No. 1233

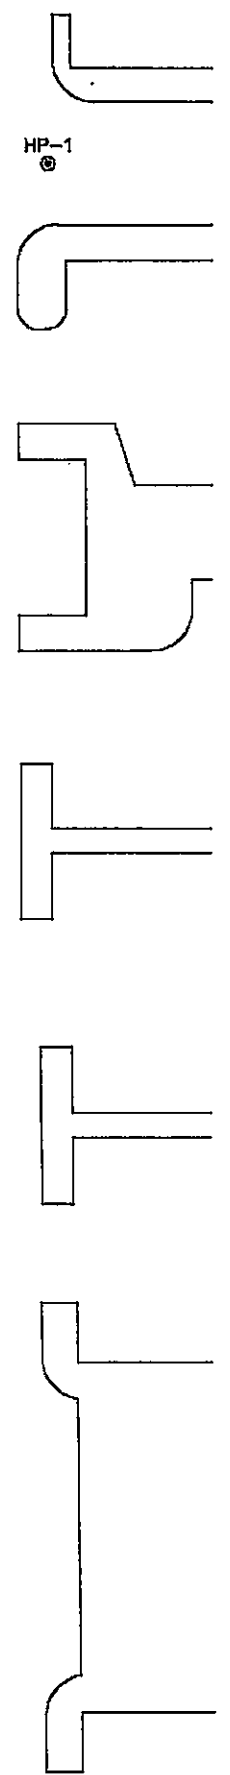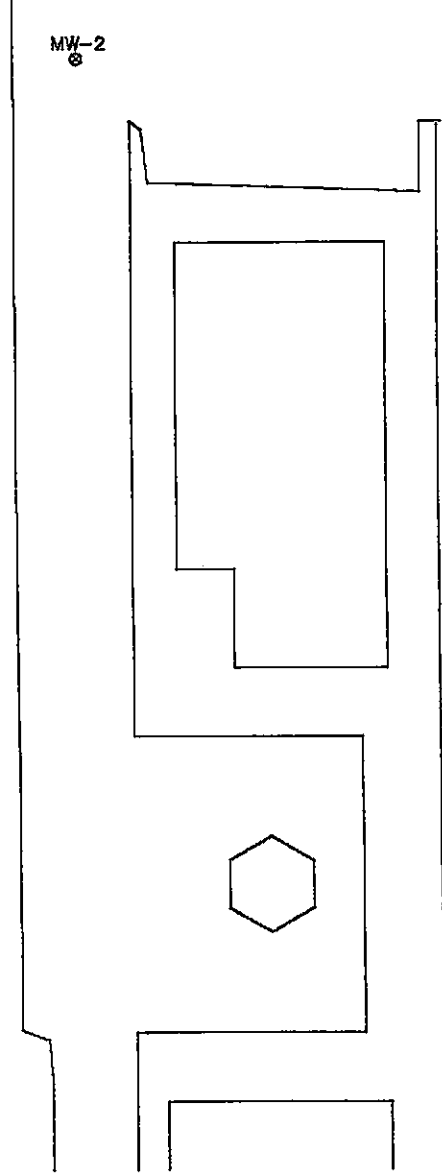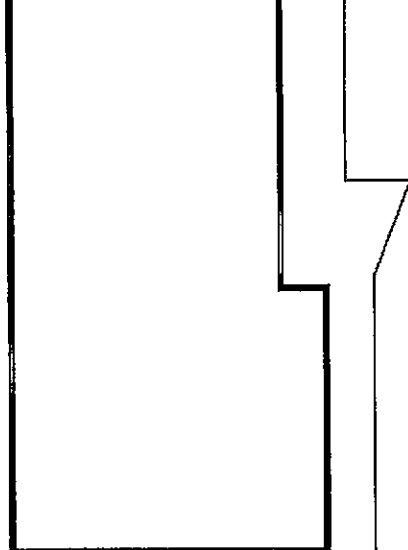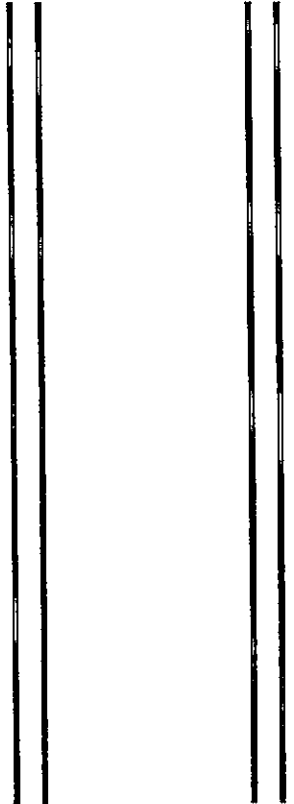

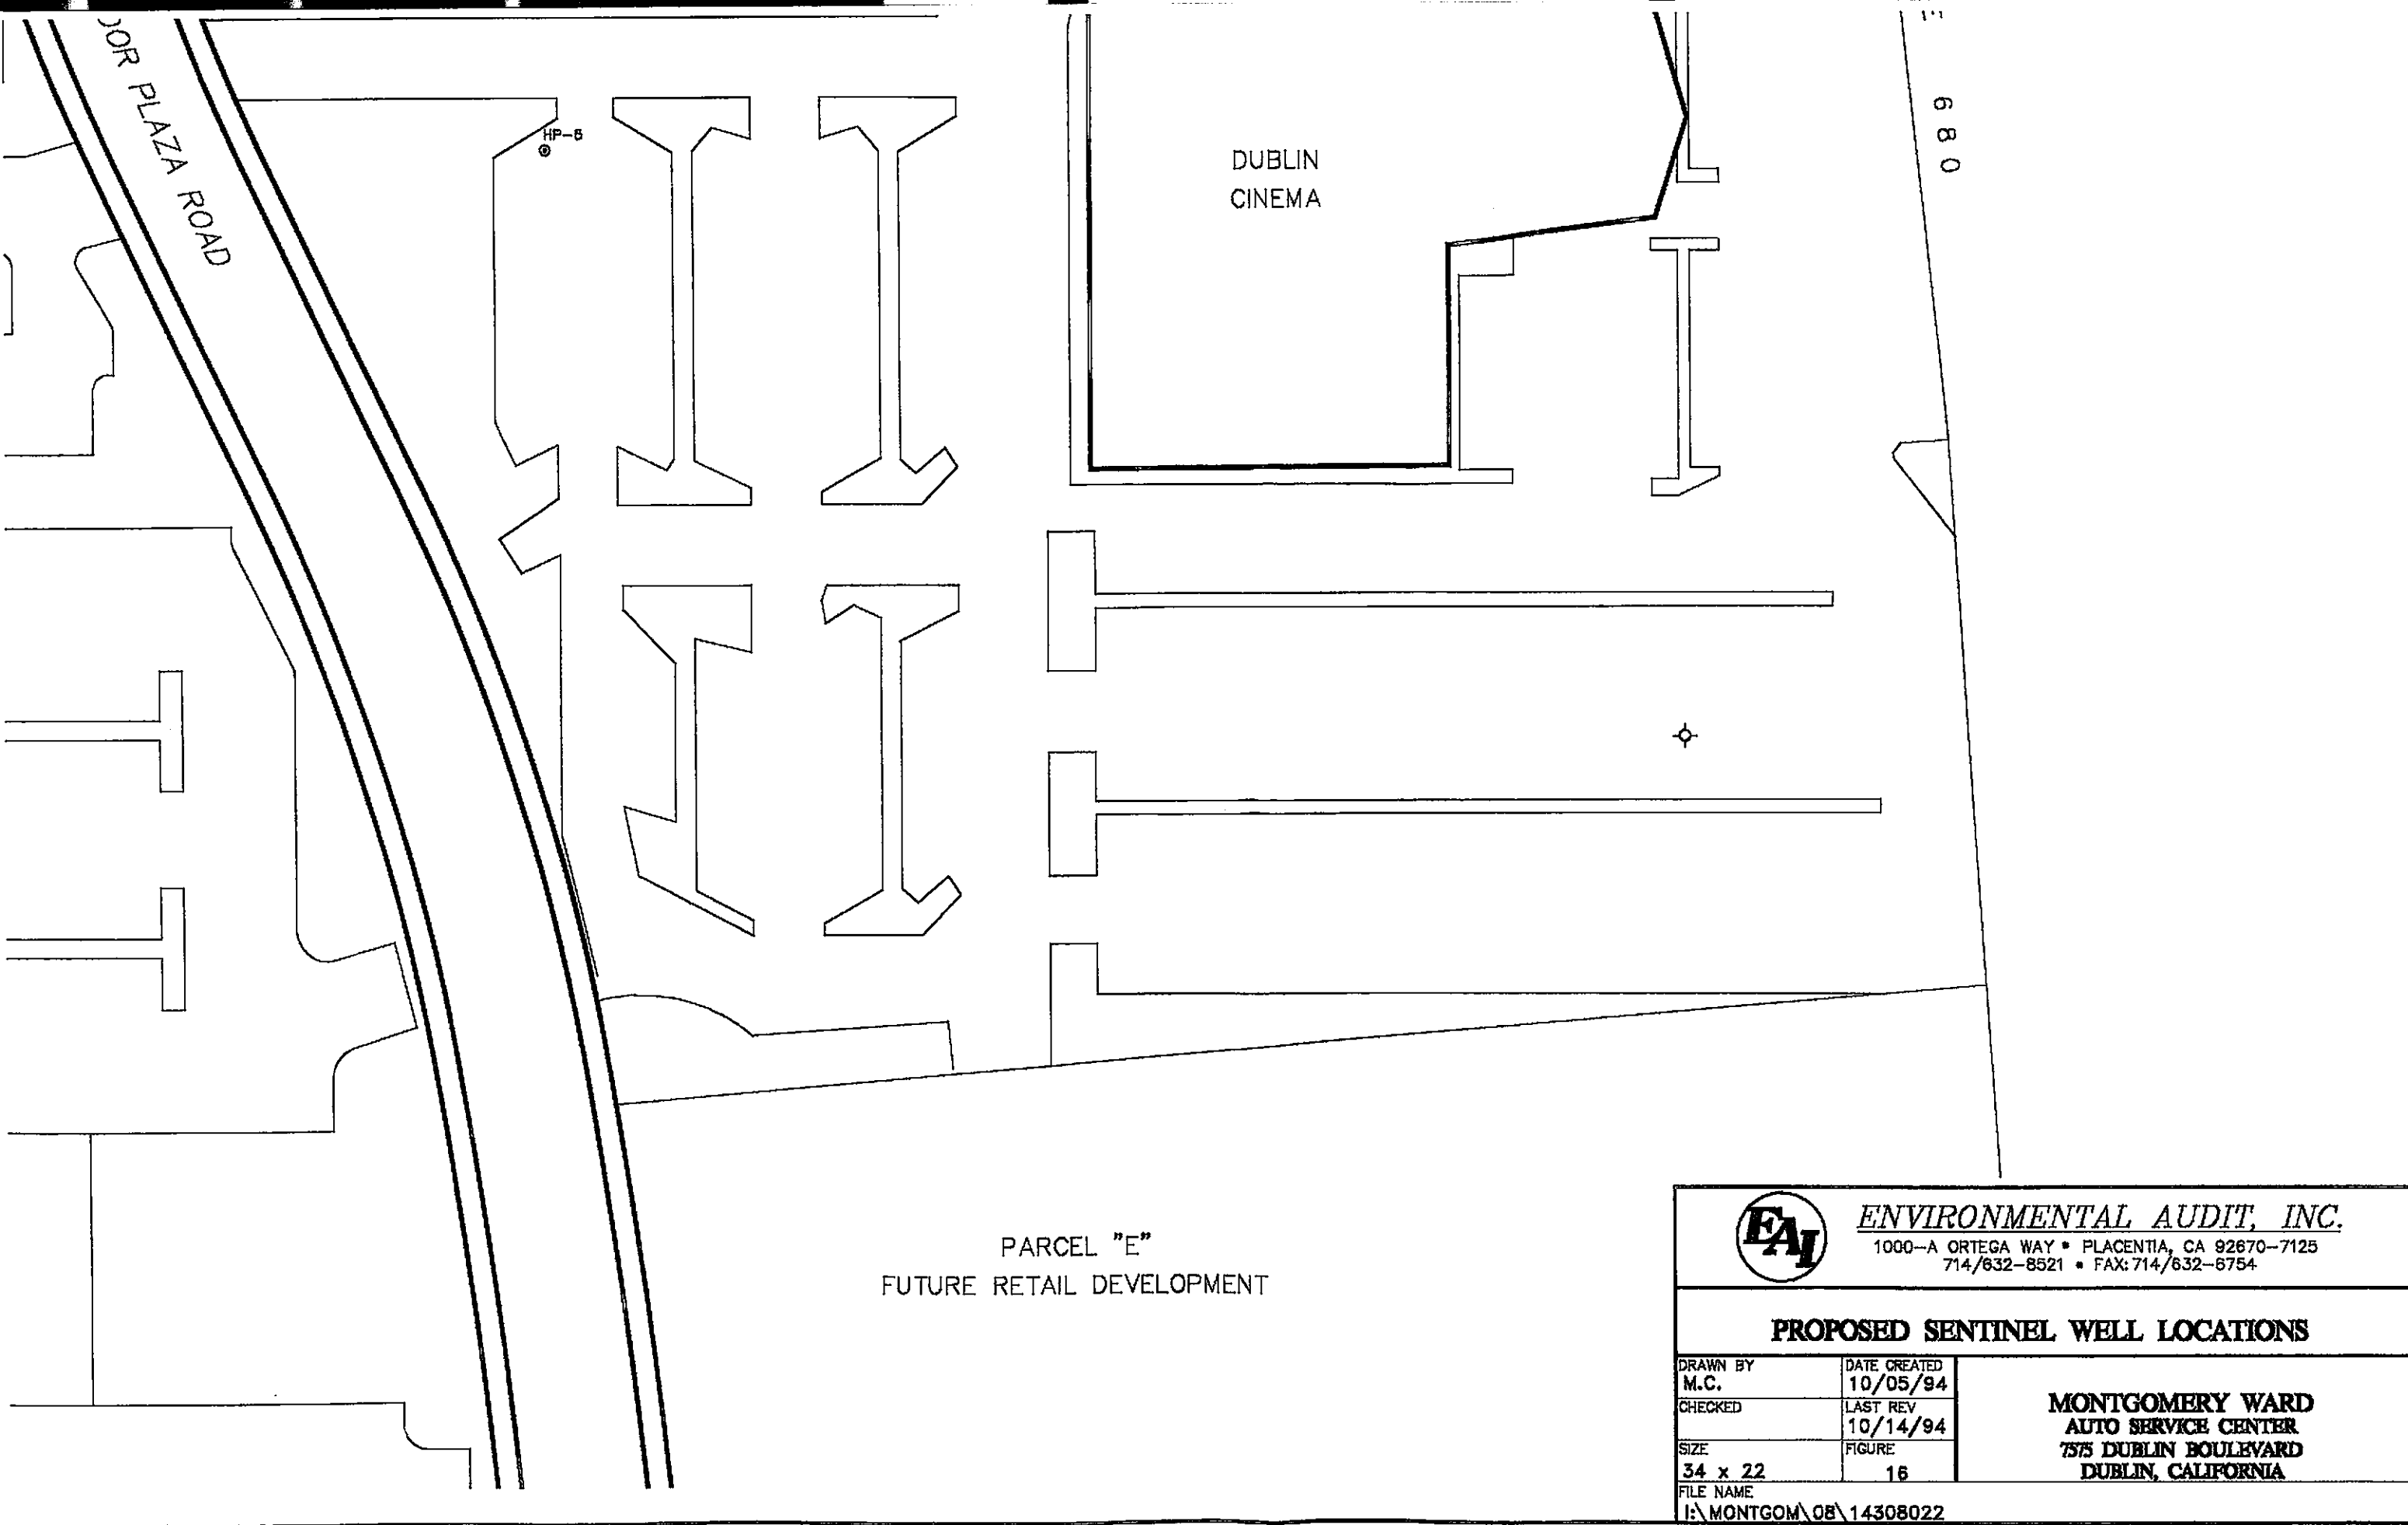

PARCEL "E"  
FUTURE RETAIL DEVELOPMENT



**ENVIRONMENTAL AUDIT, INC.**


1000-A ORTEGA WAY • PLACENTIA, CA 92670-7125  
714/632-8521 • FAX: 714/632-6754

**PROPOSED SENTINEL WELL LOCATIONS**

DRAWN BY M.C.	DATE CREATED 10/05/94
CHECKED	LAST REV 10/14/94
SIZE 34 x 22	FIGURE 16

**MONTGOMERY WARD  
AUTO SERVICE CENTER  
7575 DUBLIN BOULEVARD  
DUBLIN, CALIFORNIA**


FILE NAME  
I:\MONTGOM\08\14308022

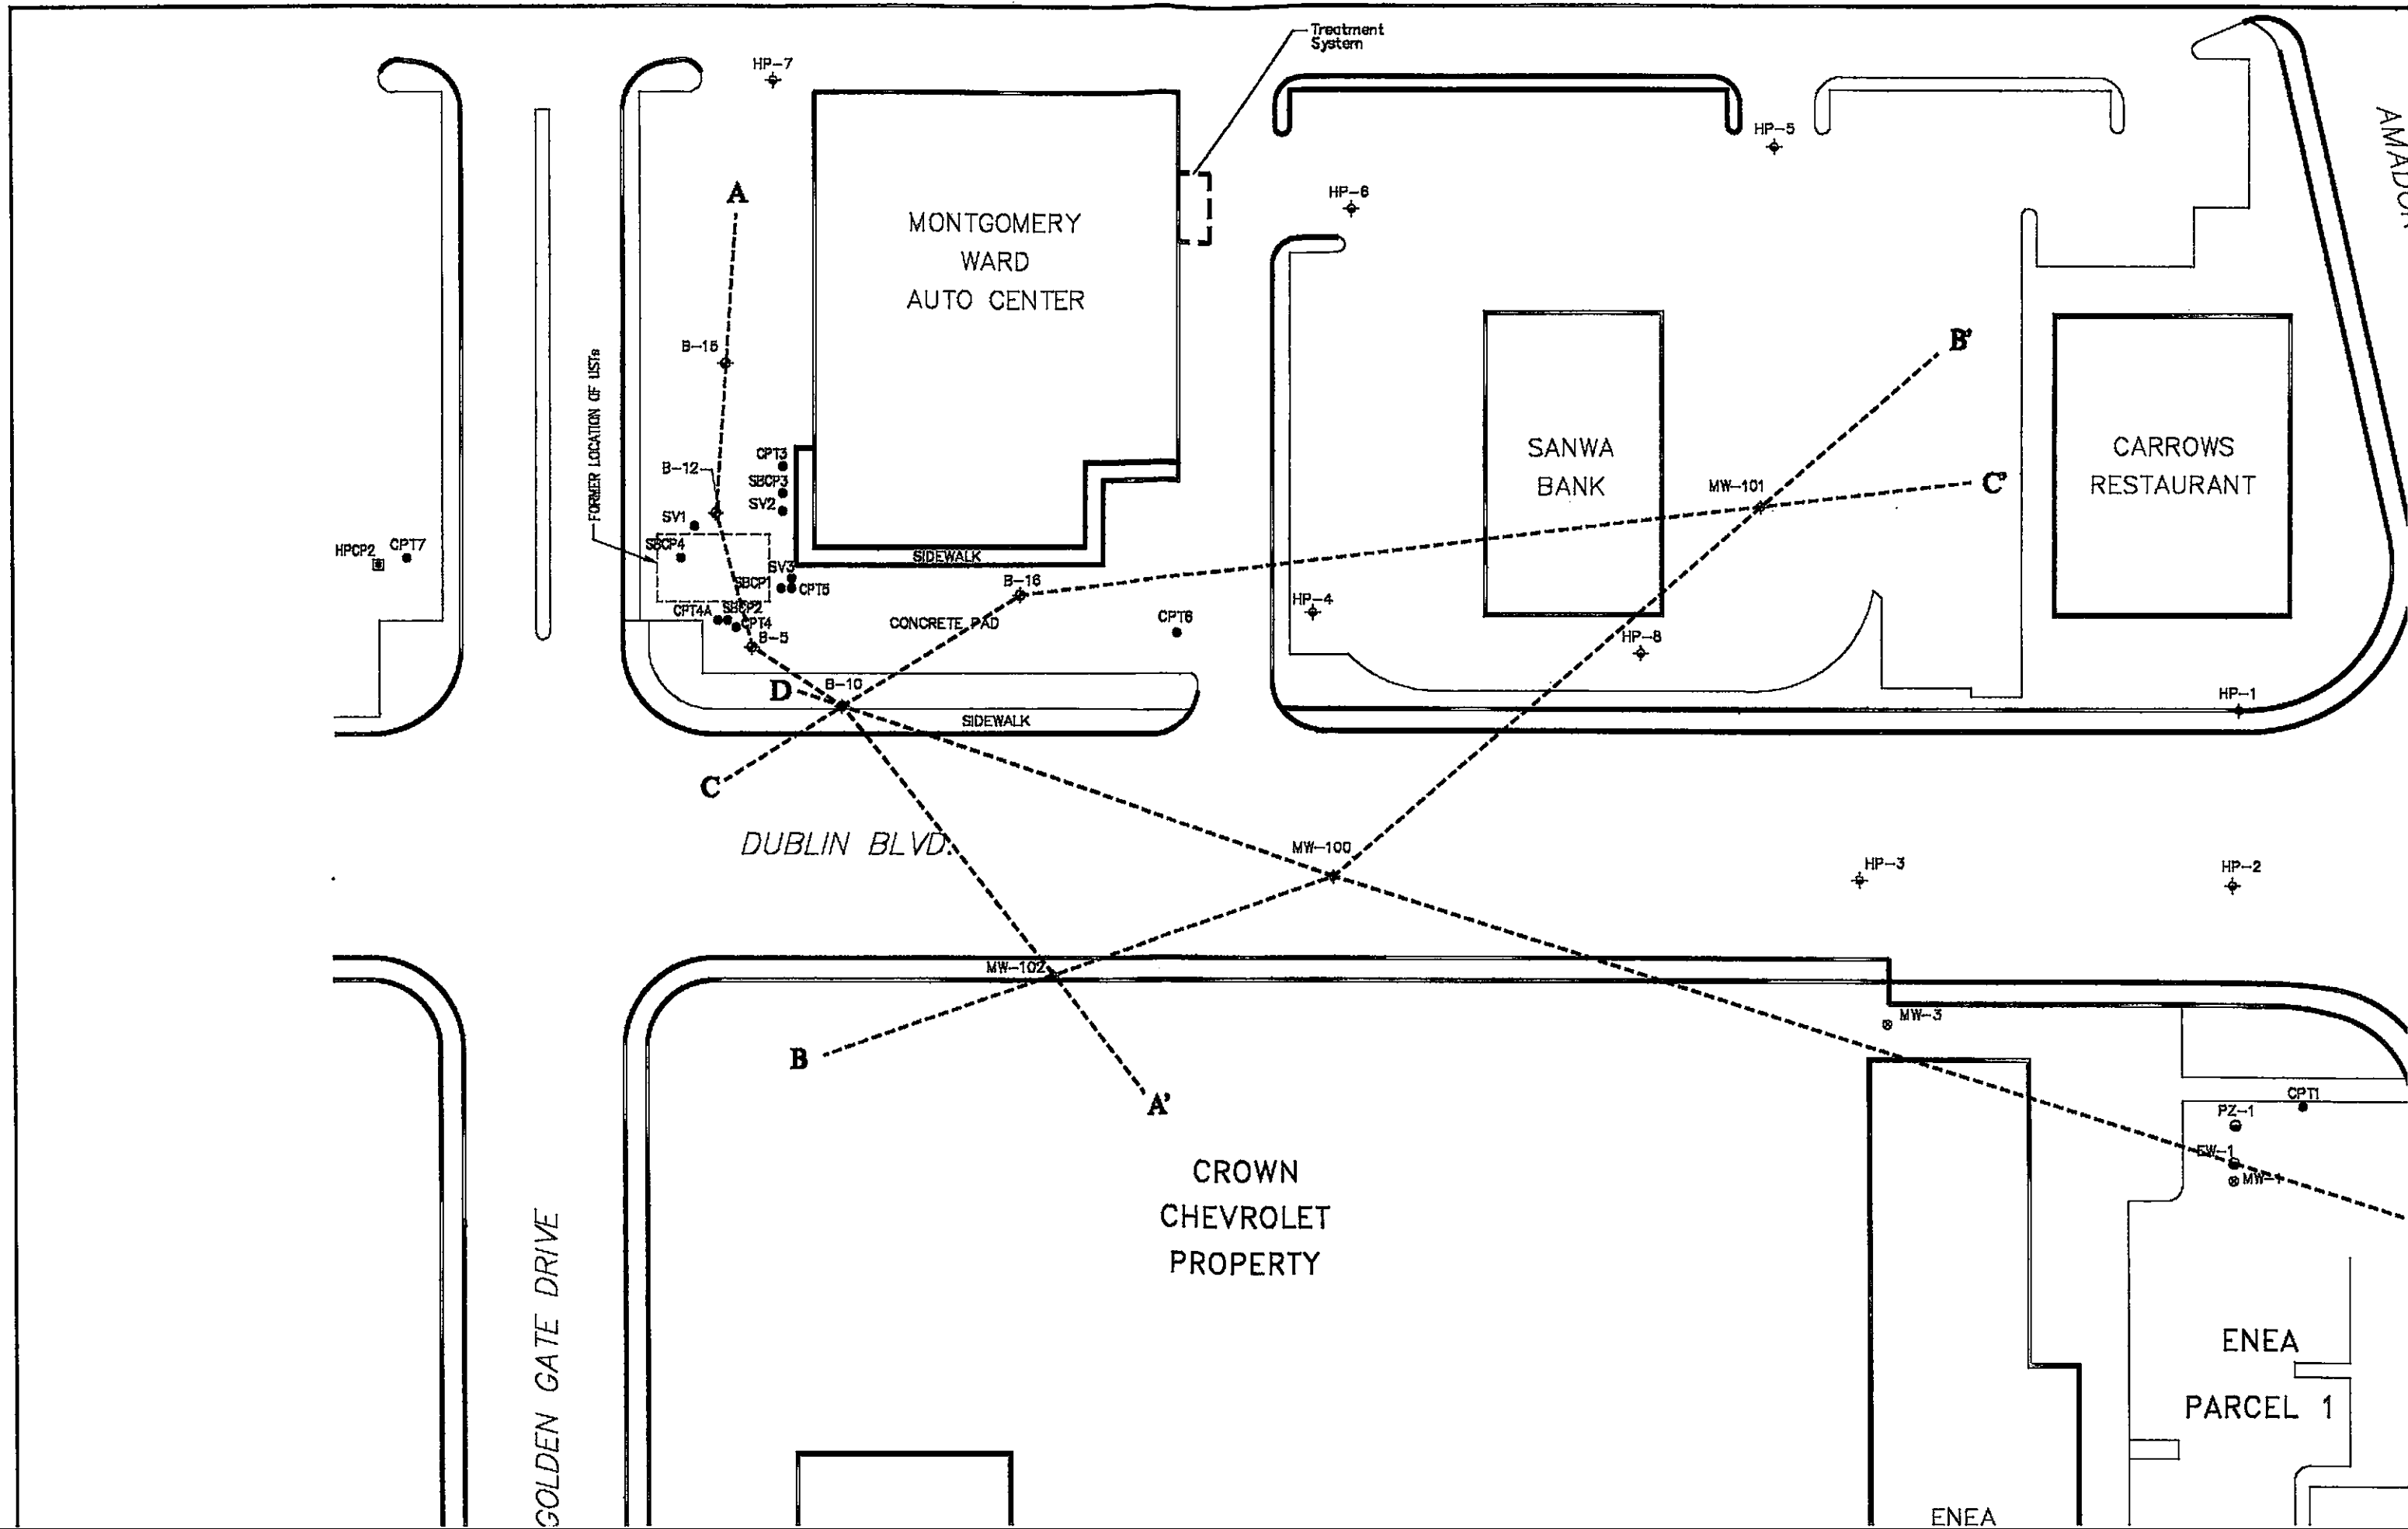


EXPLANATION:

- ⊕ ADS GROUND WATER MONITORING WELL
- ⊕ EAI GROUND WATER MONITORING WELL
- ⊗ HLA GROUND WATER MONITORING WELL
- EPIGENE GROUND WATER MONITORING WELL
- CYPRESS GROUND WATER MONITORING WELL
- EAI CPT LOCATION
- ⊠ EAI CPT HYDROPUNCH LOCATION
- ⊕ EAI HYDROPUNCH LOCATION
- ⊙ EPIGENE HYDROPUNCH

• All wells surveyed to the city of Dublin Benchmark No DUB-680 (elevation = 331.60 feet MSL)

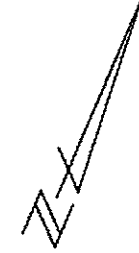

DUBLIN BLVD.

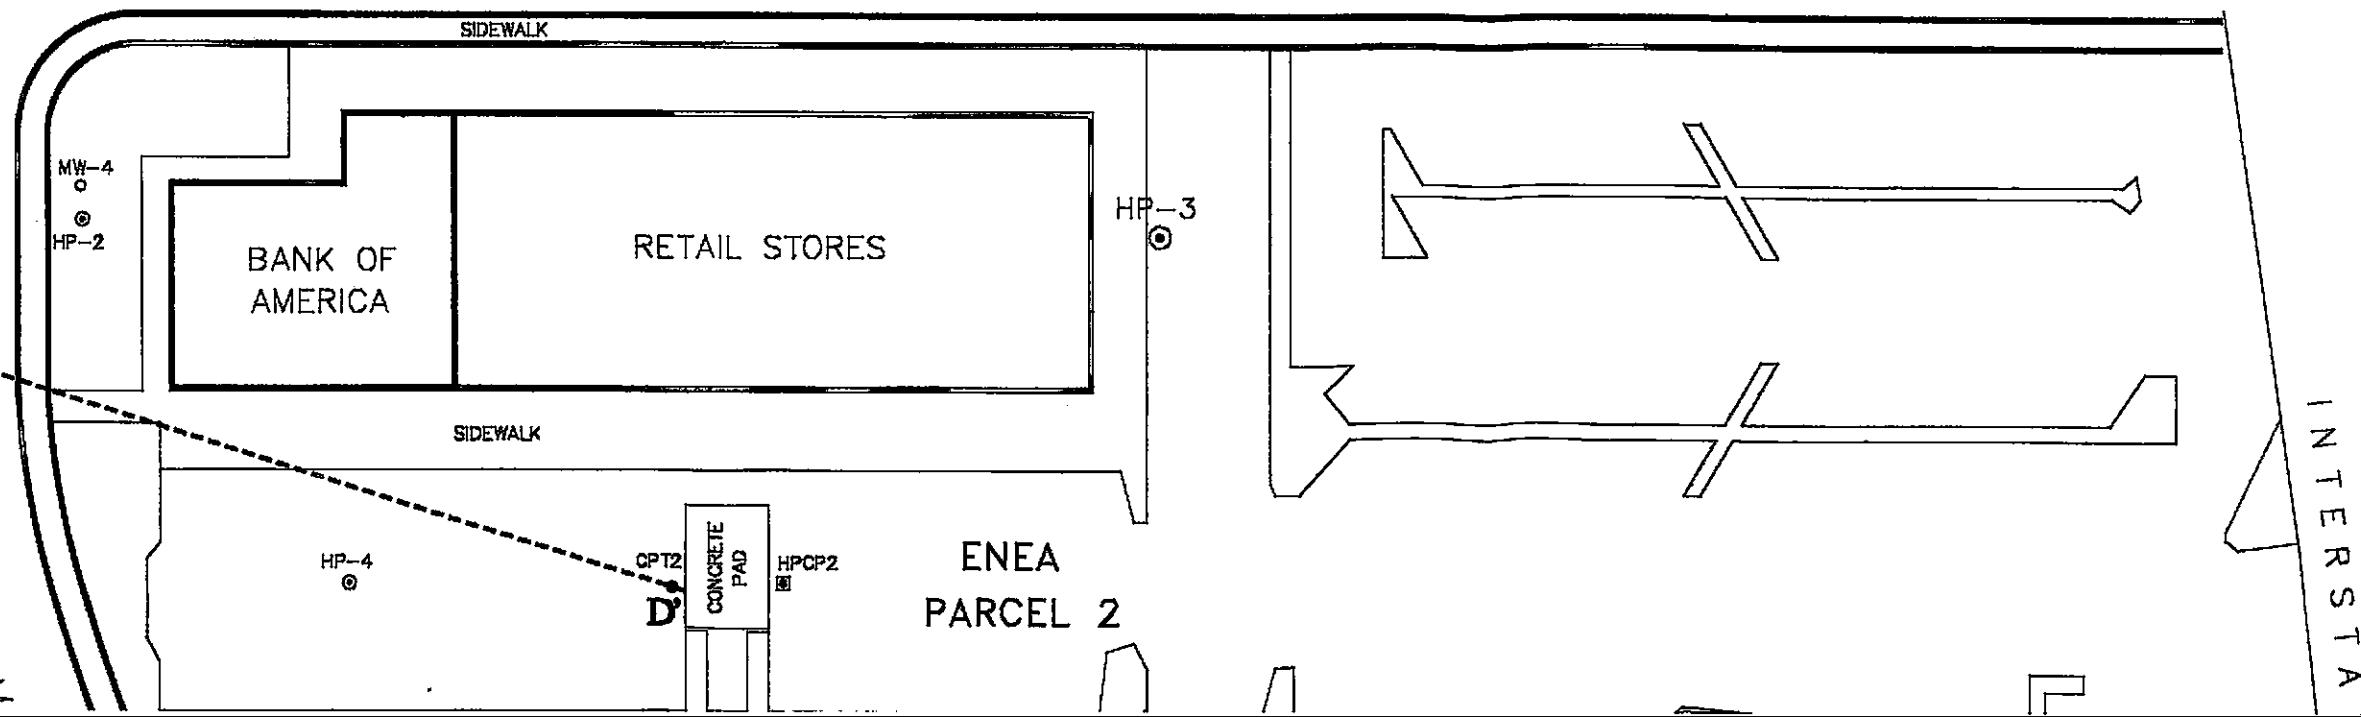

SALES  
OFFICE

SERVICE DEPT.






PLAZA


HP-1  
⊙

MW-2  
⊙

0 50'  
APPROX. SCALE

Job No. 1233

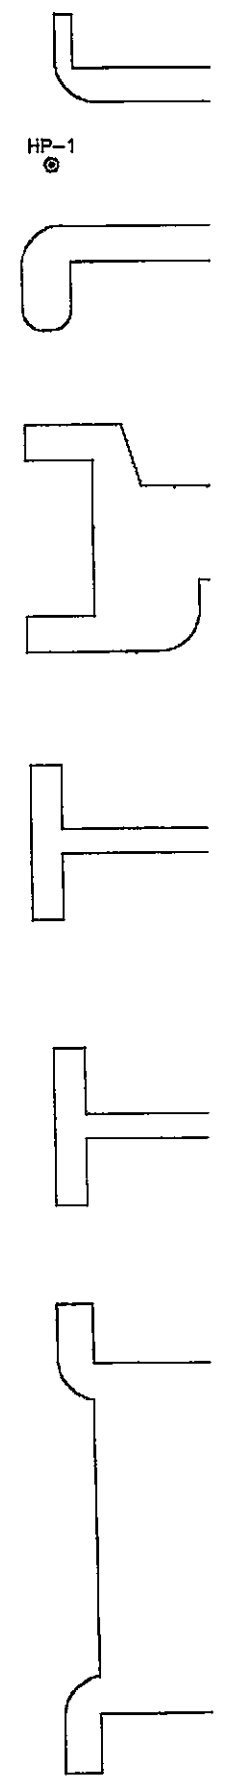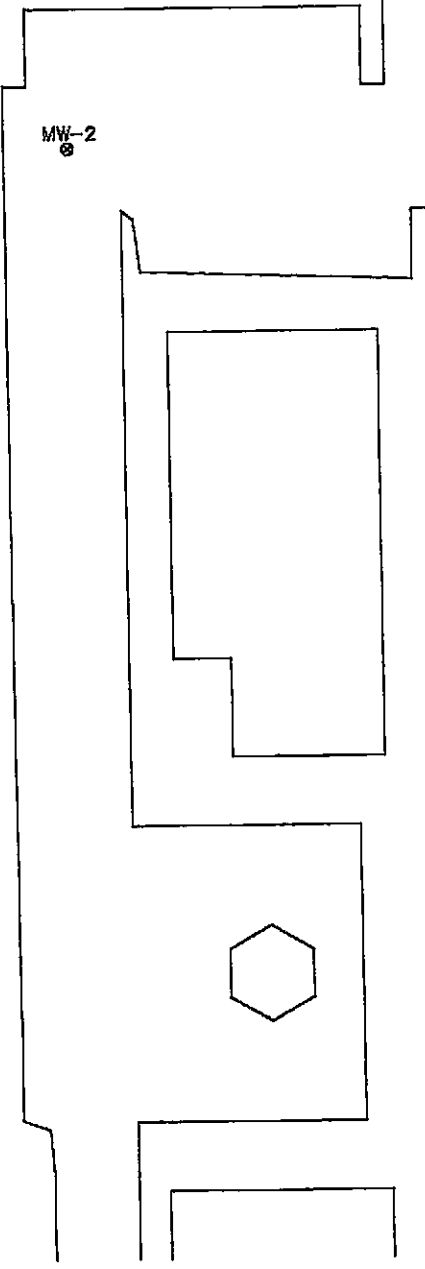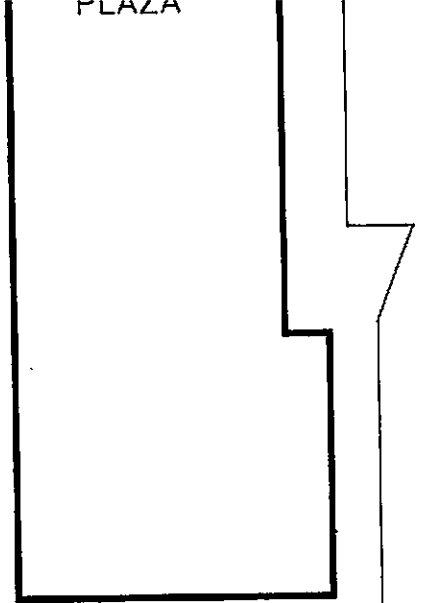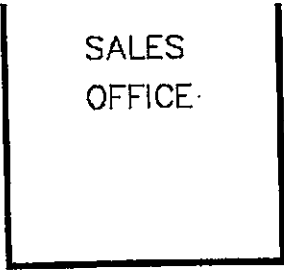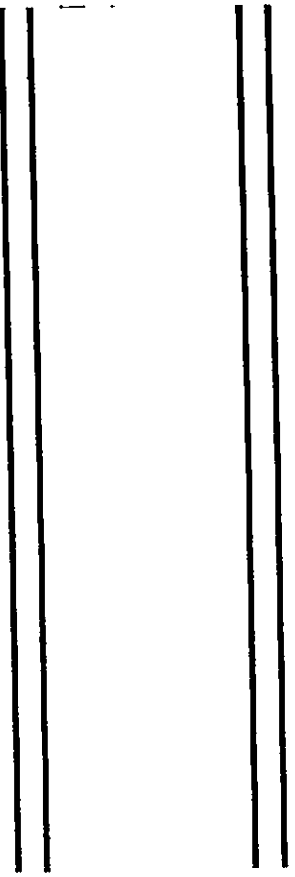

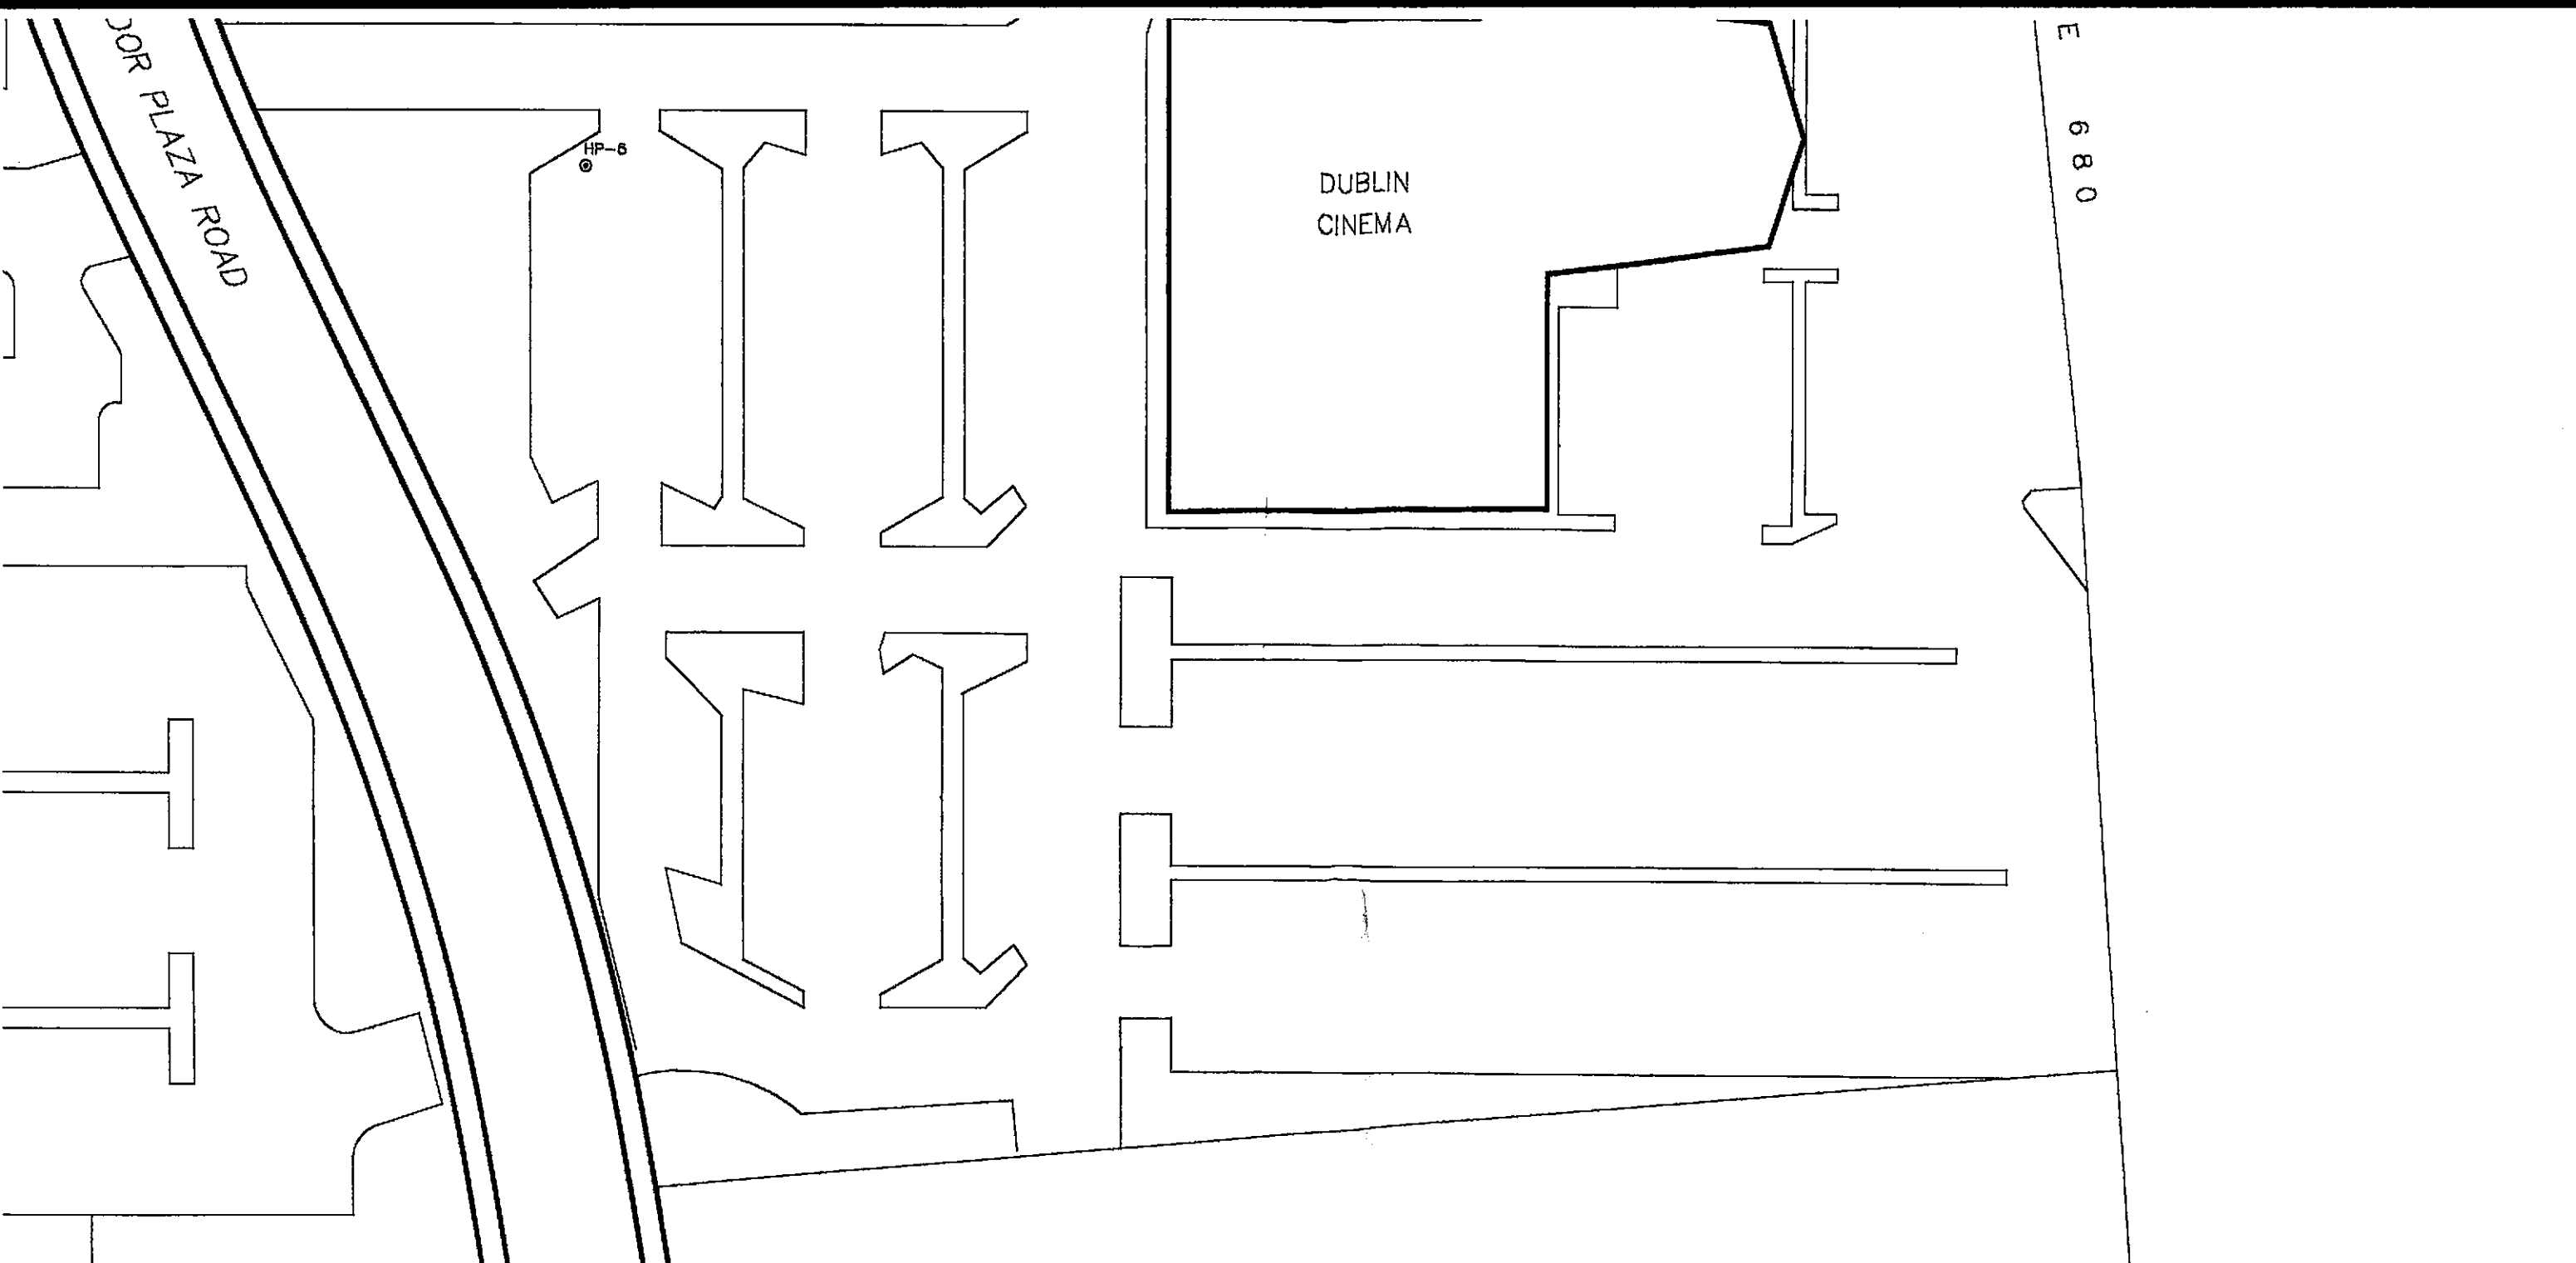

PARCEL "E"  
FUTURE RETAIL DEVELOPMENT




**ENVIRONMENTAL AUDIT, INC.**  
1000-A ORTEGA WAY • PLACENTIA, CA 92670-7125  
714/632-8521 • FAX: 714/632-6734

**CROSS SECTION LOCATION MAP**

DRAWN BY M.C.	DATE CREATED 10/05/94
CHECKED	LAST REV 10/14/94
SIZE 34 x 22	FIGURE 4
FILE NAME I:\MONTGOM\08\14308022	

**MONTGOMERY WARD  
AUTO SERVICE CENTER  
755 DUBLIN BOULEVARD  
DUBLIN, CALIFORNIA**



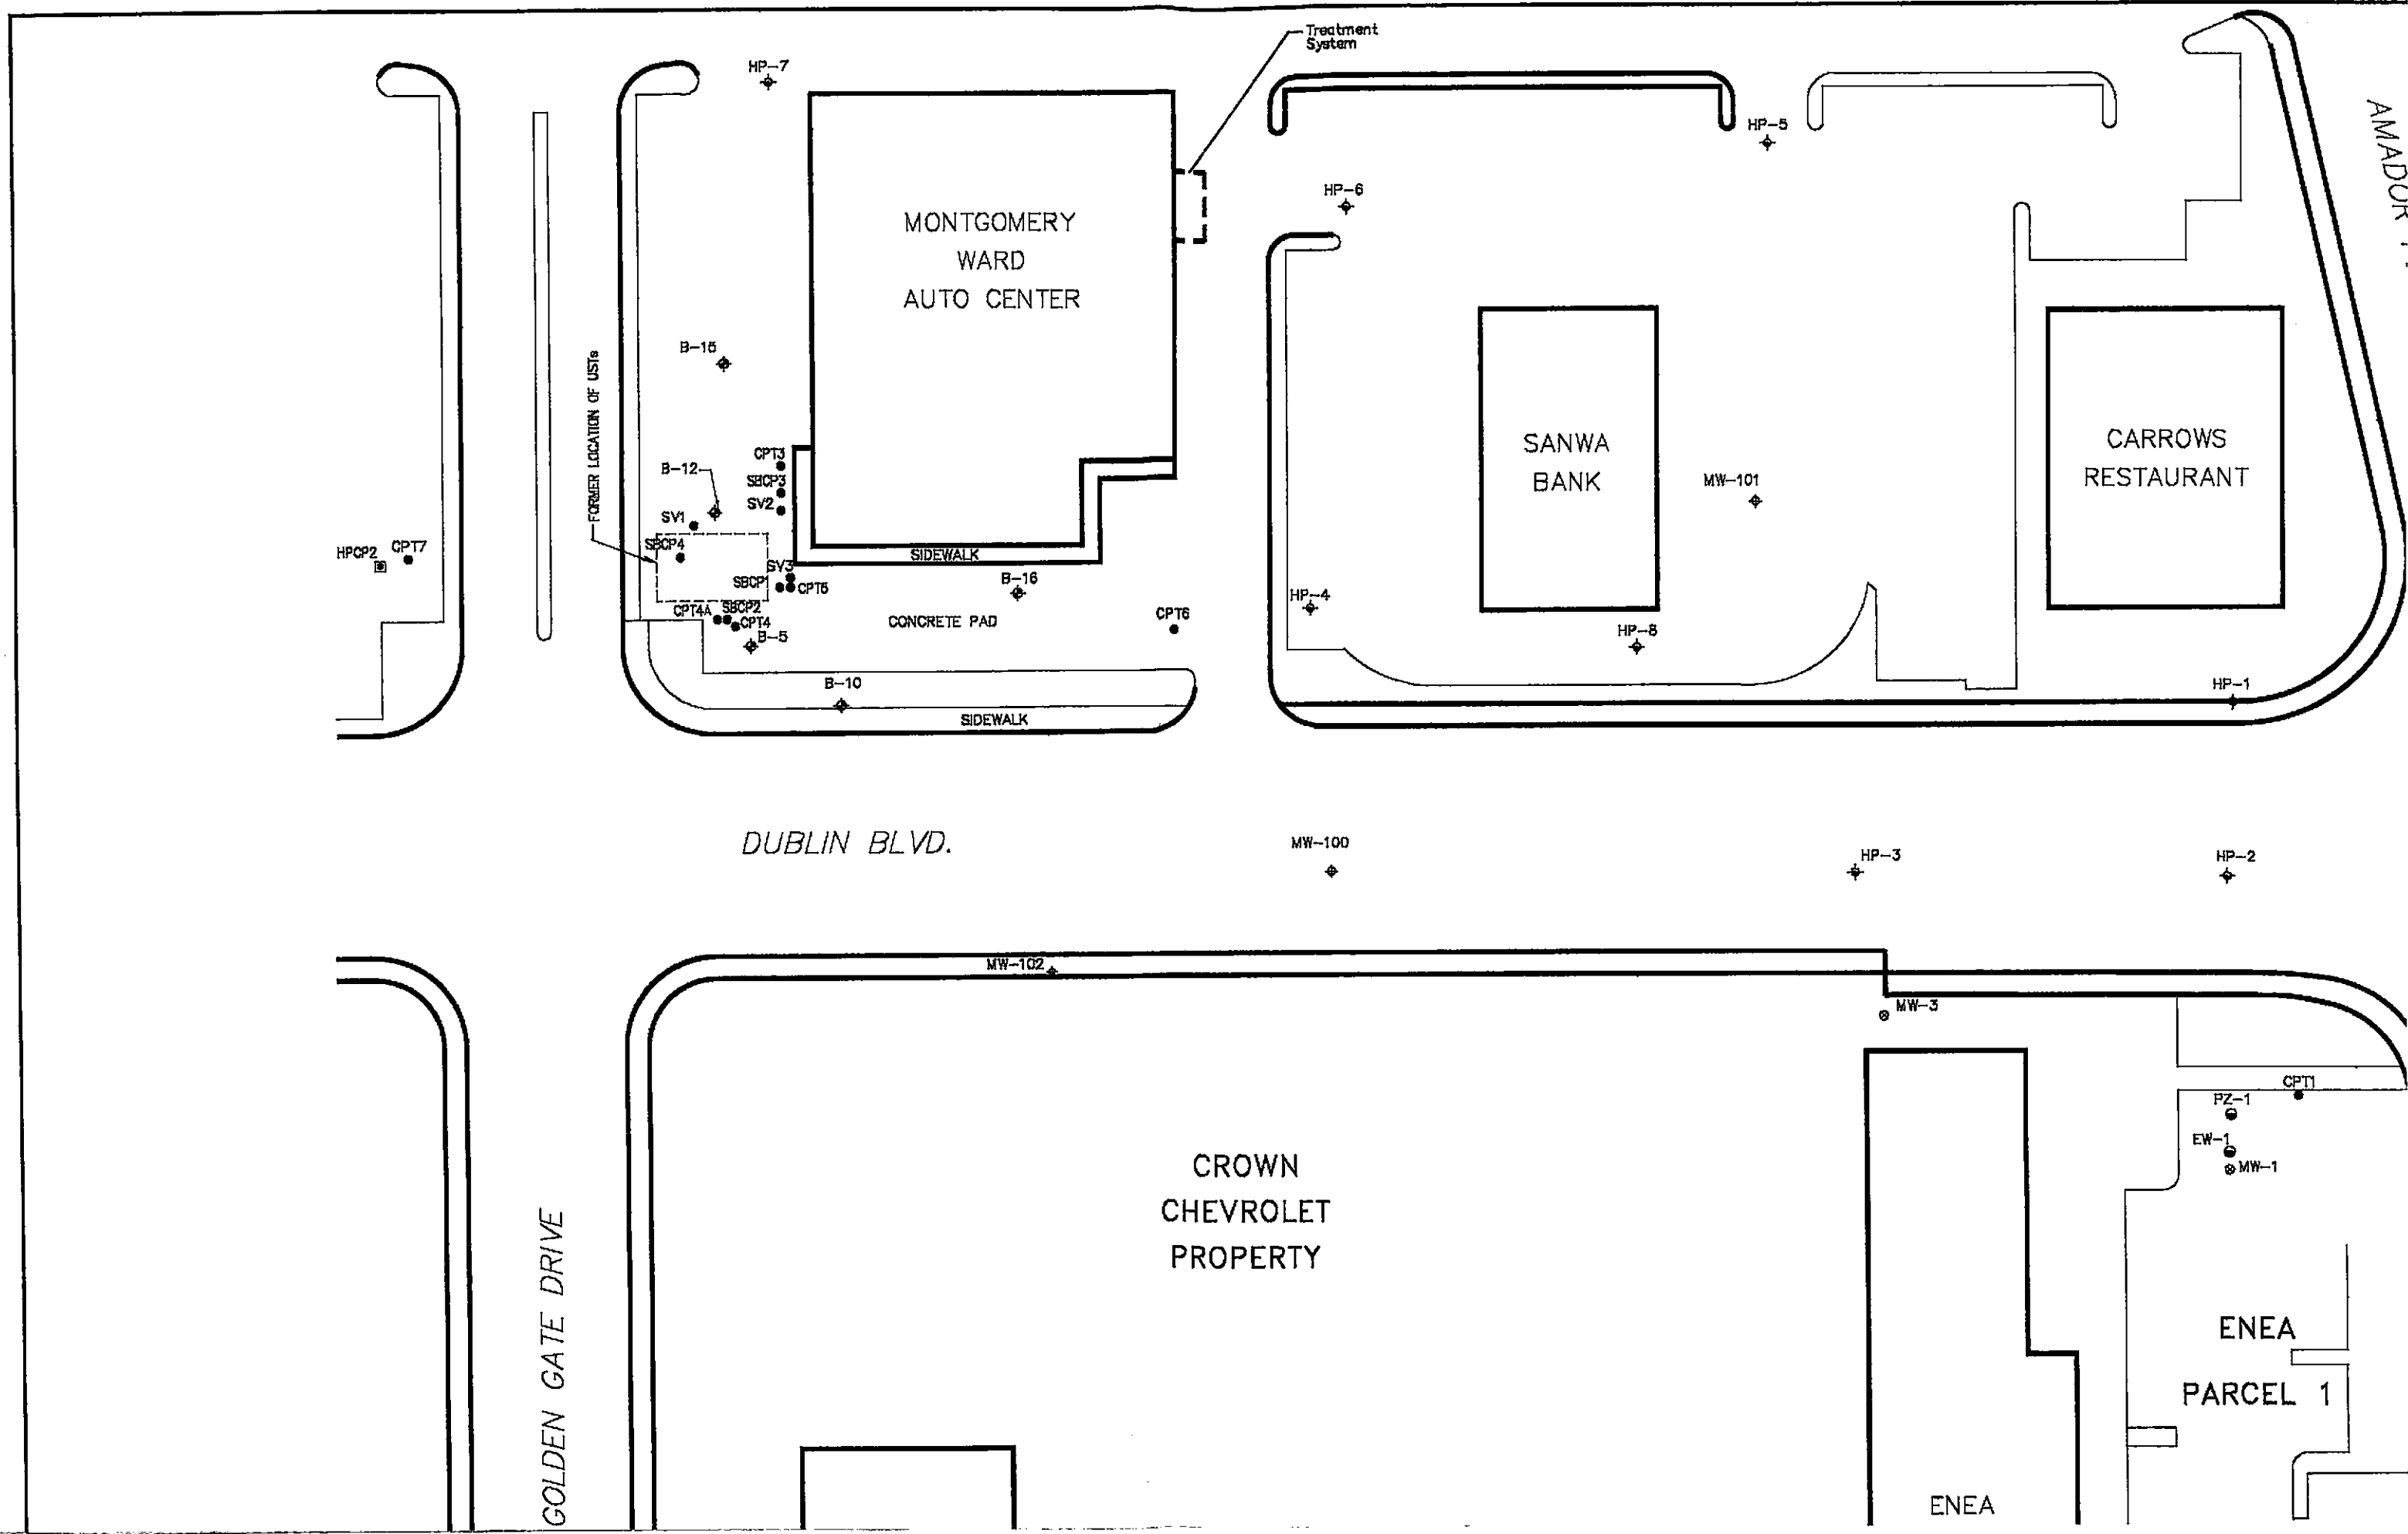

MONTGOMERY  
WARD  
AUTO CENTER

SANWA  
BANK

CARROWS  
RESTAURANT

CROWN  
CHEVROLET  
PROPERTY

ENEA  
PARCEL 1

DUBLIN BLVD.

GOLDEN GATE DRIVE

AMADOR

Treatment System

FORMER LOCATION OF US6

SIDEWALK

CONCRETE PAD


SIDEWALK

ENEA


EXPLANATION:

- ⊕ ADS GROUND WATER MONITORING WELL
- ⊕ EAI GROUND WATER MONITORING WELL
- ⊗ HLA GROUND WATER MONITORING WELL
- EPIGENE GROUND WATER MONITORING WELL
- CYPRESS GROUND WATER MONITORING WELL
- EAI CPT LOCATION
- EAI CPT HYDROPUNCH LOCATION
- ⊕ EAI HYDROPUNCH LOCATION
- ⊙ EPIGENE HYDROPUNCH

- All wells surveyed to the city of Dublin Benchmark No DUB-680 (elevation = 331.60 feet MSL)

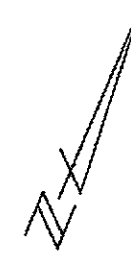

DUBLIN BLVD.

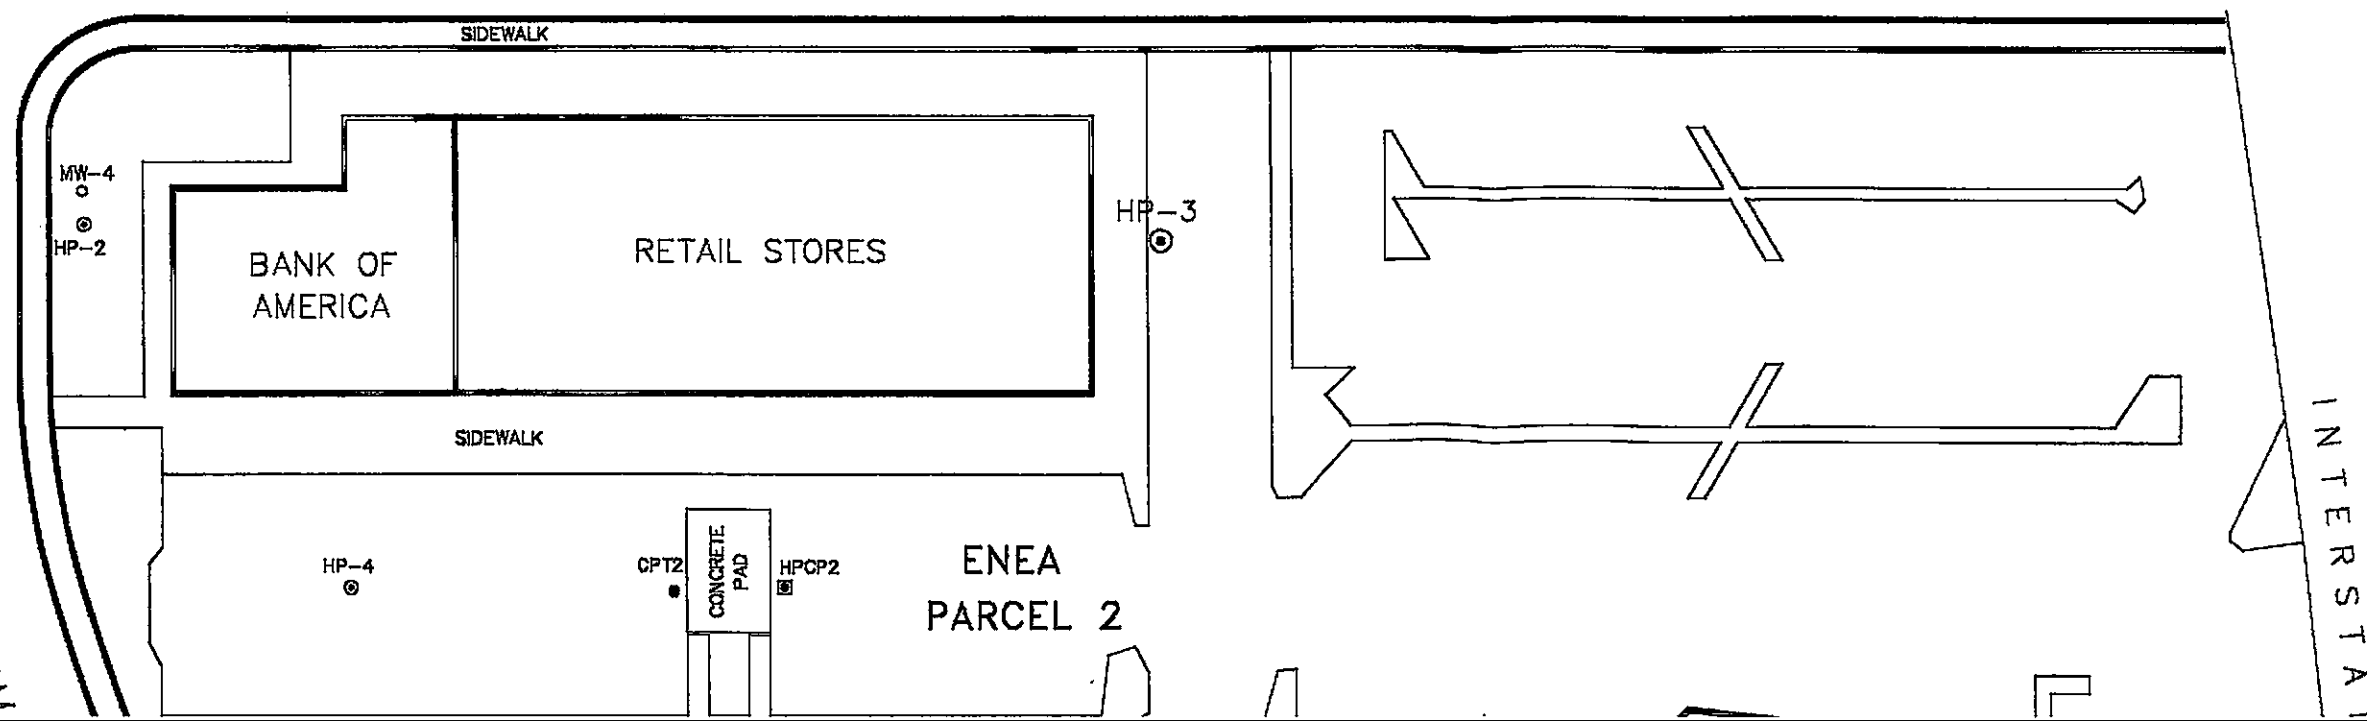

SALES  
OFFICE


SERVICE DEPT.

PLAZA


HP-1  
⊙

MW-2  
⊙

0 50'  
APPROX. SCALE

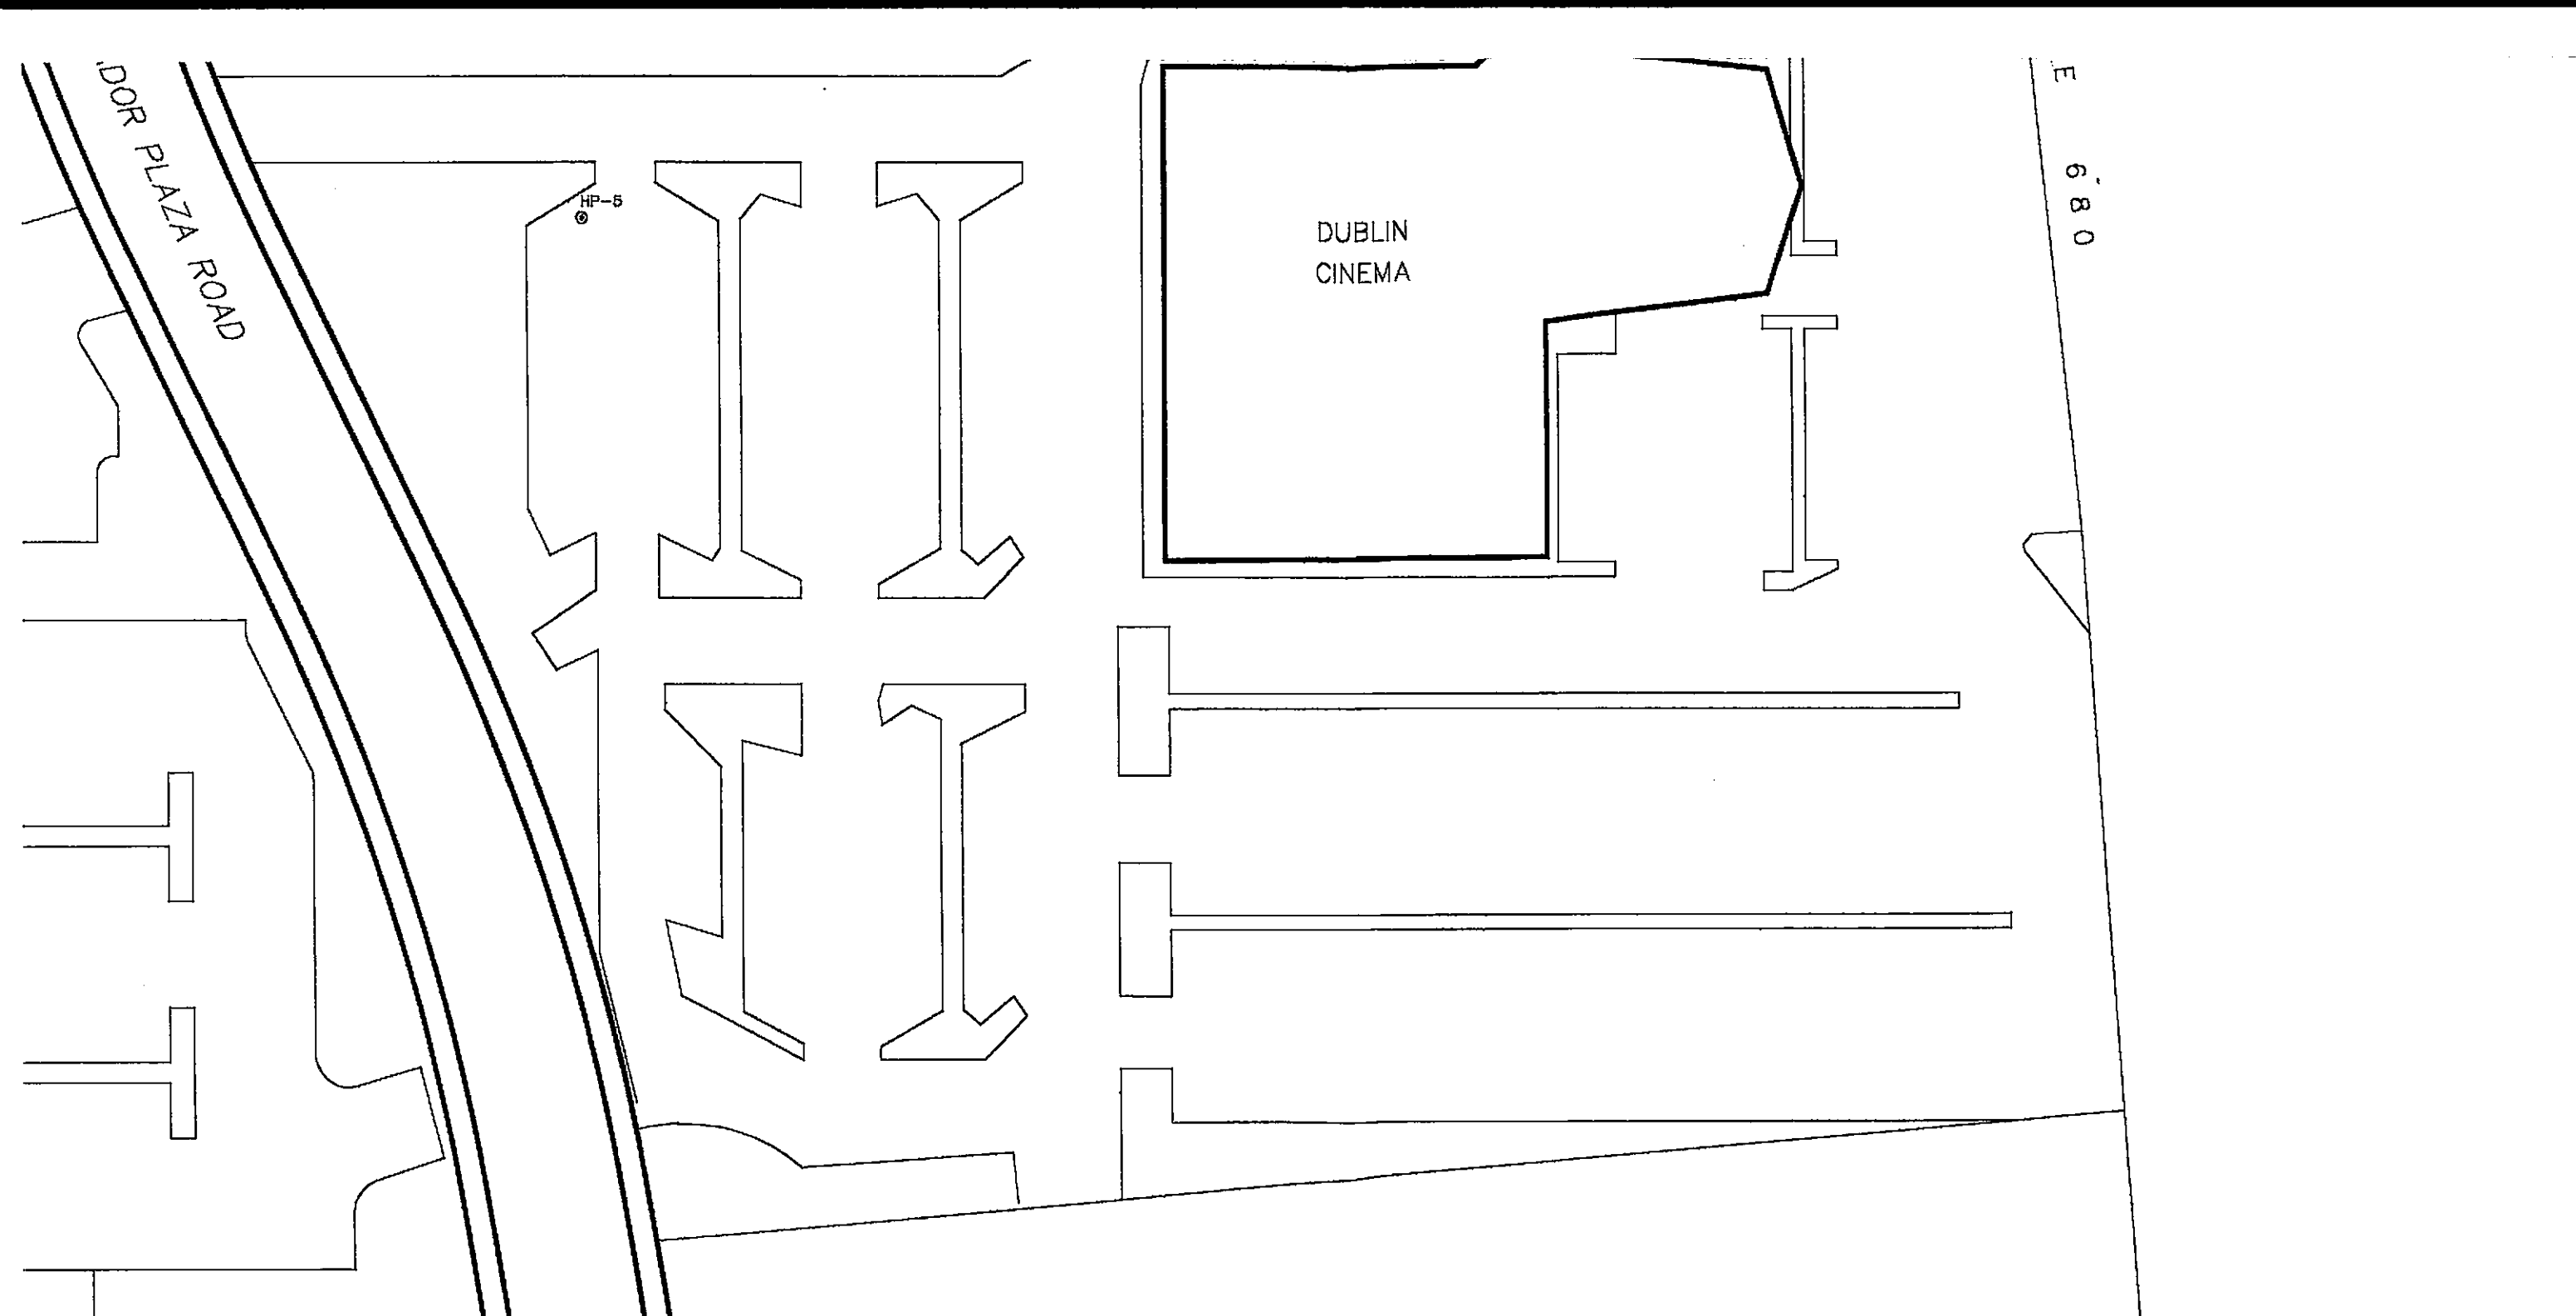

PARCEL "E"  
FUTURE RETAIL DEVELOPMENT

 <b>ENVIRONMENTAL AUDIT, INC.</b> 1000-A ORTEGA WAY • PLACENTIA, CA 92670-7125 714/632-8521 • FAX: 714/632-6754	
<b>SITE PLAN</b>	
DRAWN BY M.C.	DATE CREATED 10/05/94
CHECKED	LAST REV 10/14/94
SIZE 34 x 22	FIGURE 2
FILE NAME I:\MONTGOM\08\14308022	
<b>MONTGOMERY WARD          AUTO SERVICE CENTER          7575 DUBLIN BOULEVARD          DUBLIN, CALIFORNIA</b>	