



Sunnymere Avenue

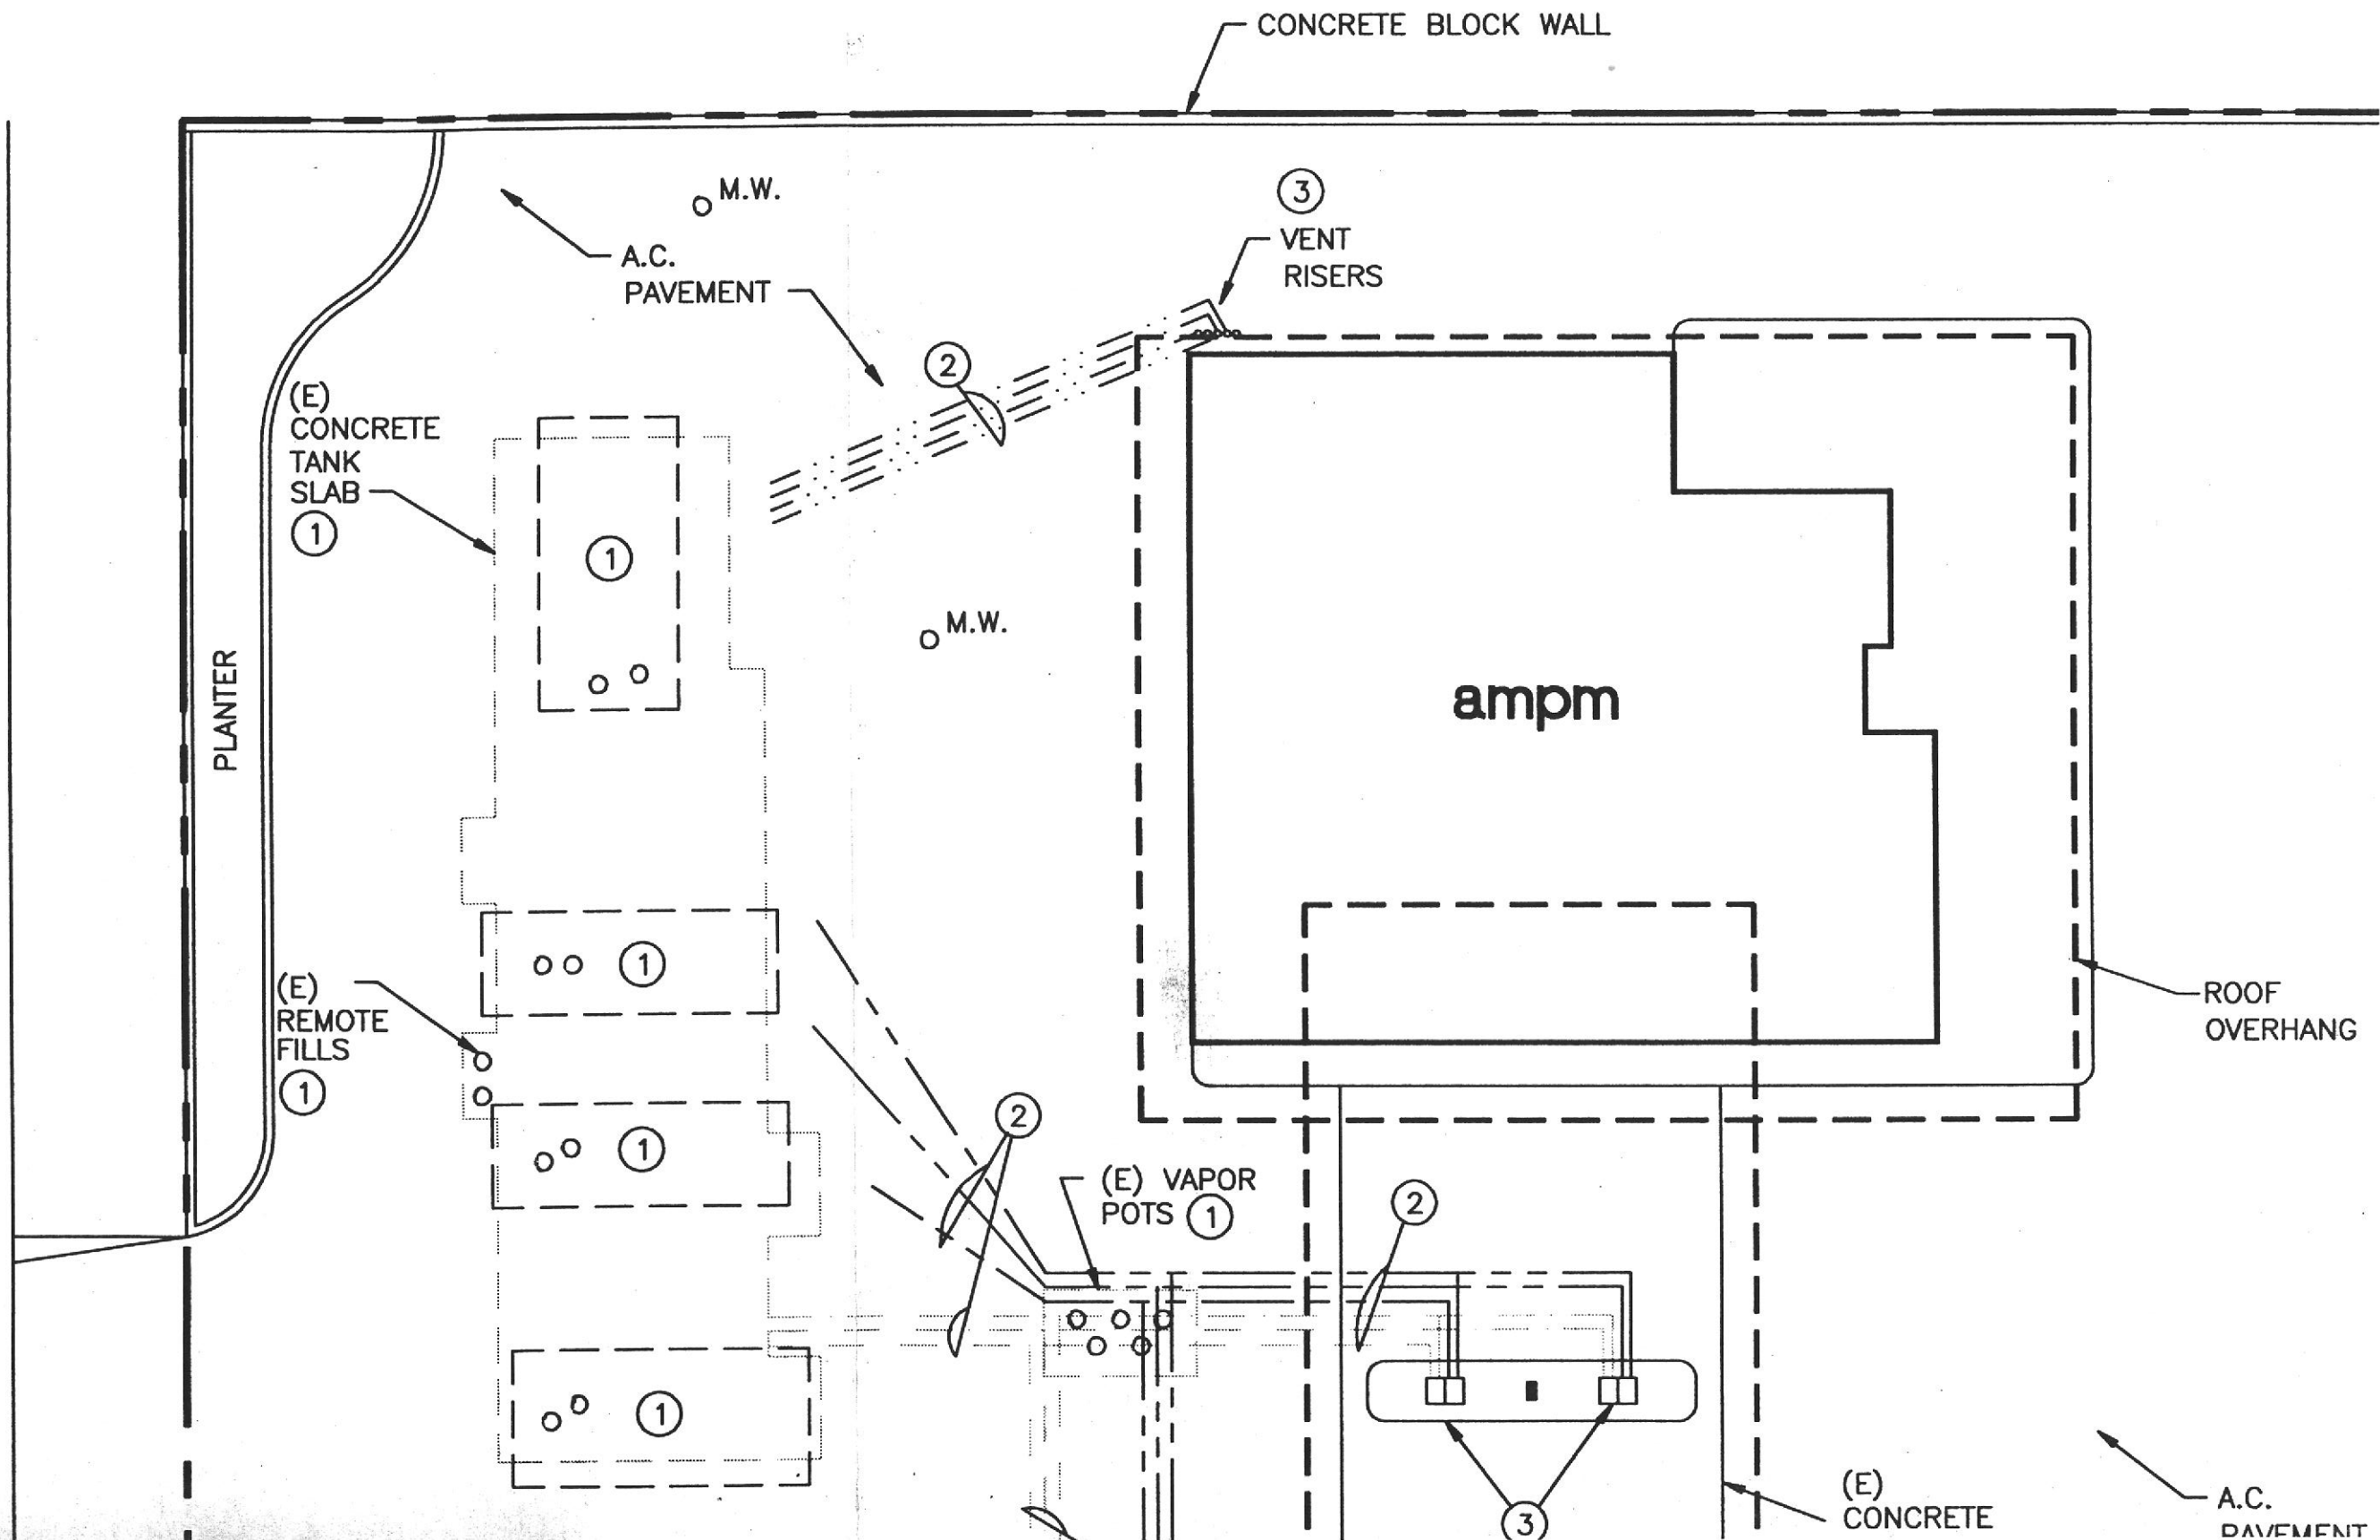

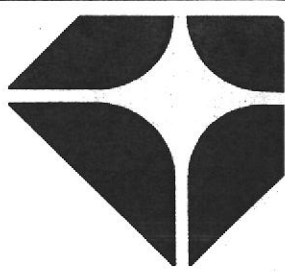

ARCO Products Company

Division of AtlanticRichfieldCompany

Retail Marketing • Design & Engineering

1055 West Seventh St.

1 Galaxy Way
te 404
icord, CA 94520
O) 680-6800
X) 680-7878

Demolition Notes

- A. CONTRACTOR SHALL VERIFY EXISTING TANKS & PIPING LOCATIONS IN FIELD. LOCATIONS SHOWN ON THIS DRAWING ARE DIAGRAMMATIC ONLY.
- B. FENCE JOB SITE WITH 6 FT. HIGH CHAIN LINK FENCE DURING BOTH DEMOLITION & CONSTRUCTION.
- C. CONTRACTOR SHALL PROTECT EXISTING BUILDING & CANOPY FINISHES & TOUCH-UP PAINT AS REQ'D.
- D. CONTRACTOR SHALL PROTECT EXISTING UNDERGROUND UTILITIES, MONITOR WELLS IN PLACE.
- E. ALL WORK & INSTALLATIONS SHALL BE DONE IN ACCORDANCE WITH ARCO TANK DRAWINGS DATED 7-1-95 AND MASTER CONSTRUCTION CONSTRUCTION SPECIFICATIONS DATED APRIL 1995. (SECTIONS RELEVANT TO THIS PROJECT)

Plan Notes - Base Bid


- ① REMOVE (4) SINGLE-WALL STEEL PRODUCT TANKS AS FOLLOWS:
 - (2) 4,000 GALLON
 - (2) 6,000 GALLONREMOVE TANK SLAB, REMOTE FILLS, POWER & SIGNAL CONDUIT TO EDGE OF EXCAVATION. LEAVE EXCAVATION OPEN FOR OTHERS. STOCKPILE EXCAVATION SPOILS COVERED WITH VISQUEEN ONSITE FOR REUSE.
- ② REMOVE ALL PRODUCT, VAPOR RECOVERY & VENT PIPING. REMOVE ALL VAPOR POTS. LEAVE TRENCHES OPEN FOR OTHERS. STOCKPILE EXCAVATION SPOILS COVERED WITH VISQUEEN ONSITE FOR REUSE.
- ③ PROTECT EXISTING ISLANDS, DISPENSERS, DISPENSER POWER & SIGNAL CONDUIT, VENT RISERS @ BUILDING IN PLACE FOR REUSE.

Plan Notes - Alternate Bid

- ① REMOVE (4) SINGLE-WALL STEEL PRODUCT TANKS AS FOLLOWS:
 - (2) 4,000 GALLON
 - (2) 6,000 GALLONREMOVE TANK SLAB, REMOTE FILLS, POWER & SIGNAL CONDUIT TO EDGE OF EXCAVATION.

M.W. ○


PLANTER

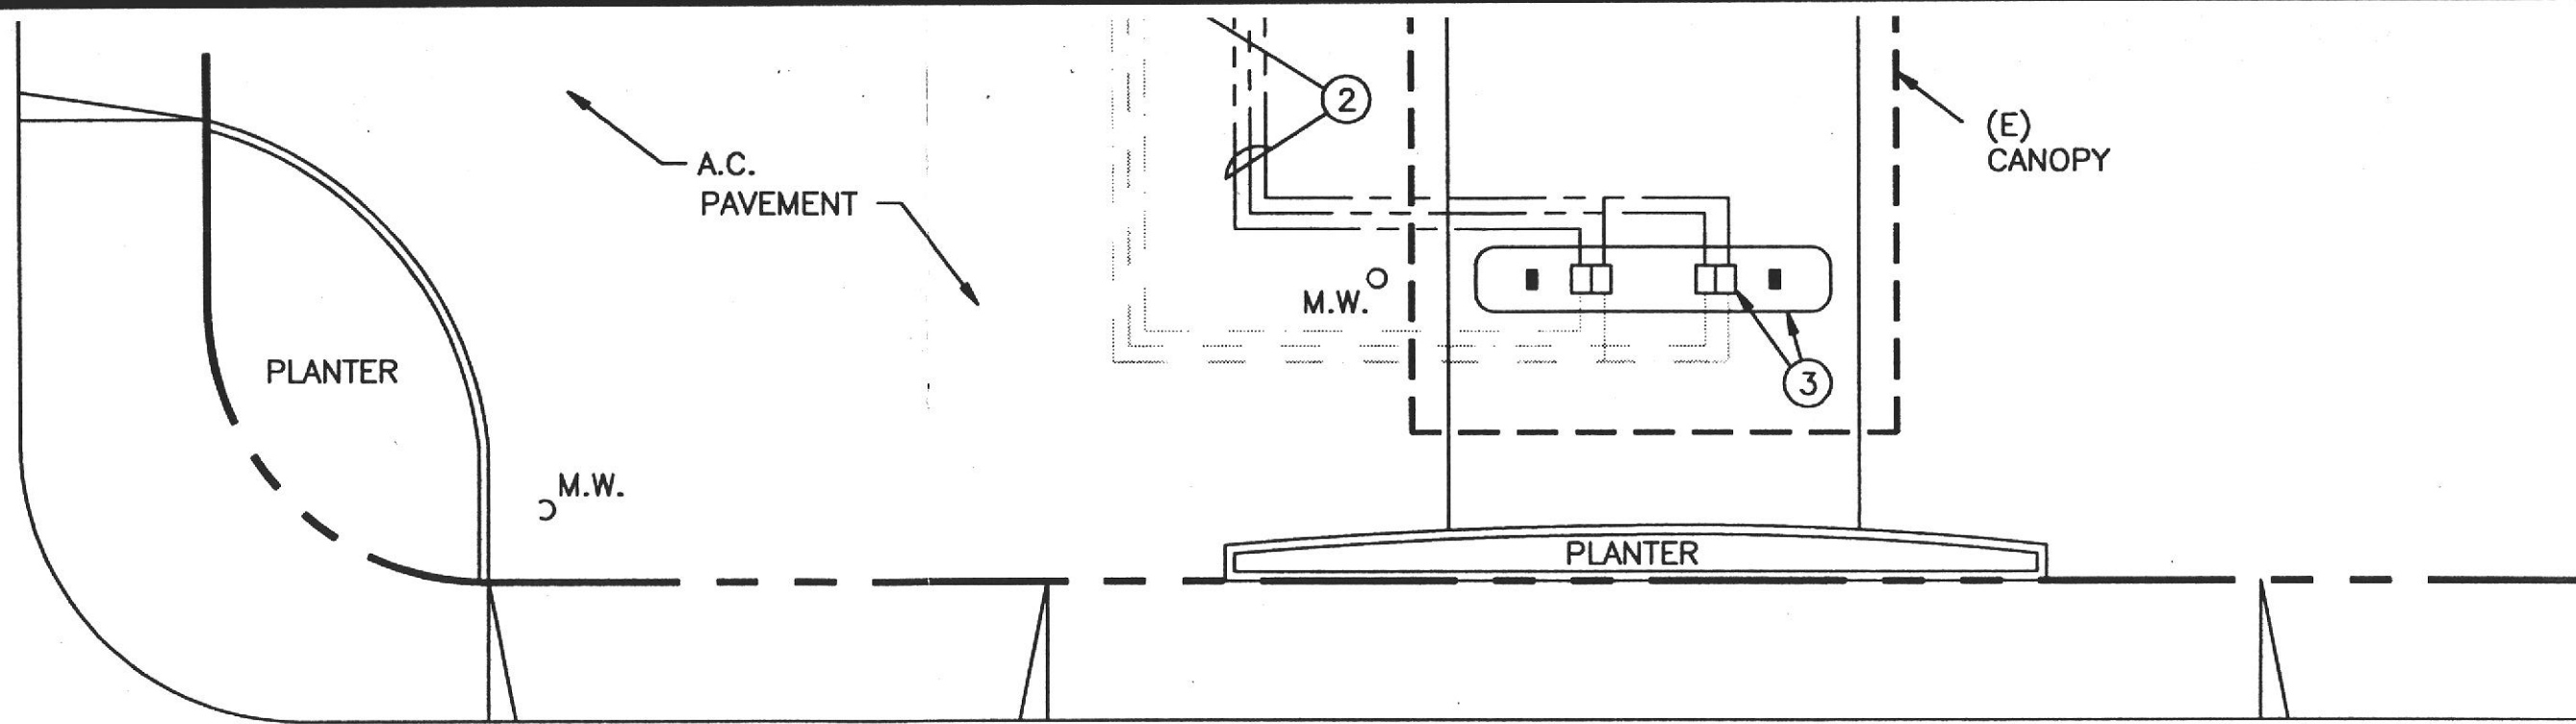

Seminary Avenue

SITE PLAN

SCALE: 1" = 10'-0"

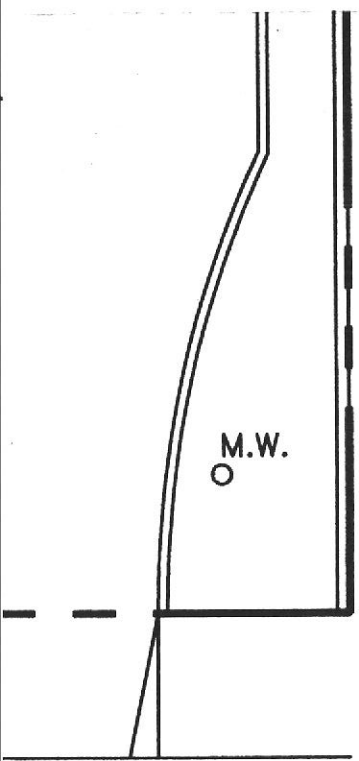


BACKFILL & COMPACT EXCAVATION. PROVIDE NEW A.C. PAVING.

- ② REMOVE ALL PRODUCT, VAPOR RECOVERY & VENT PIPING. REMOVE ALL VAPOR POTS. BACKFILL & COMPACT TRENCHES. REPAIR A.C. PAVING & CONCRETE DRIVE SLAB.
- ③ PROTECT EXISTING ISLANDS, DISPENSERS, DISPENSER POWER & SIGNAL CONDUIT, VENT RISERS @ BUILDING IN PLACE FOR REUSE.

ENVIRONMENTAL
 PROTECTION
 95 E. 321 AVENUE

 10 Su Co (5)
TAIT
 TAIT & ASSOCIATES, INC.
 CONSULTING ENGINEERS (F)
 ORANGE, CA · RANCHO CORDOVA, CA



Tank + Piping Removal
 SWC Seminary Ave. • I-580
 Oakland, California
 app.

Piping Legend



DATE	REVISIONS

date	drawn
11/29/95	2D.F.
project / facility	6002
sheet / file	