

**Chevron**

FACSIMILE


Chevron Products Company
P.O. Box 5004
San Ramon, CA 94583-804Date: 4-17-97Philip R. Briggs
Project Manager
Site Assessment & Remediation
Phone No. 510-842-9136
Fax No. 510-842-8370Company: ACHCSFax Number: 510 337-9335To: SCOTT SEERYSubject: FORMER CHEVRON SERVICE STATION # 9-2960
2416 GROVE WAY, CASTRO VALLEY.

I'M ATTACHING COPIES OF SITE REMEDIATION SYSTEM THAT
WAS INSTALLED AT THE SITE. I CONFIRMED WITH PAUL NUTI
OF WEISS THAT THE SEWER CONNECTION FOR THE SYSTEM WAS TO
THE SANITARY LINE ON GROVE WAY. THE GAS CONNECTION WAS
ALSO FROM GROVE WAY.

THE ELECTRICAL TO THE SYSTEM WAS INSTALLED
UNDERGROUND TO THE SERVICE POLE LOCATED ON REDWOOD
ROAD, AT A DEPTH OF ± 18". THIS WAS PVC CONDUIT
WAS CAPPED AT BOTH ENDS WHEN SERVICE DISCONNECTED
AND SYSTEM REMOVED. SEWER CONNECTION WAS CAPPED
AT AND MARKED ON THE PROPERTY
C.C. CURT PECK, CRTC.

Number of Pages 4

WEISS ASSOCIATES

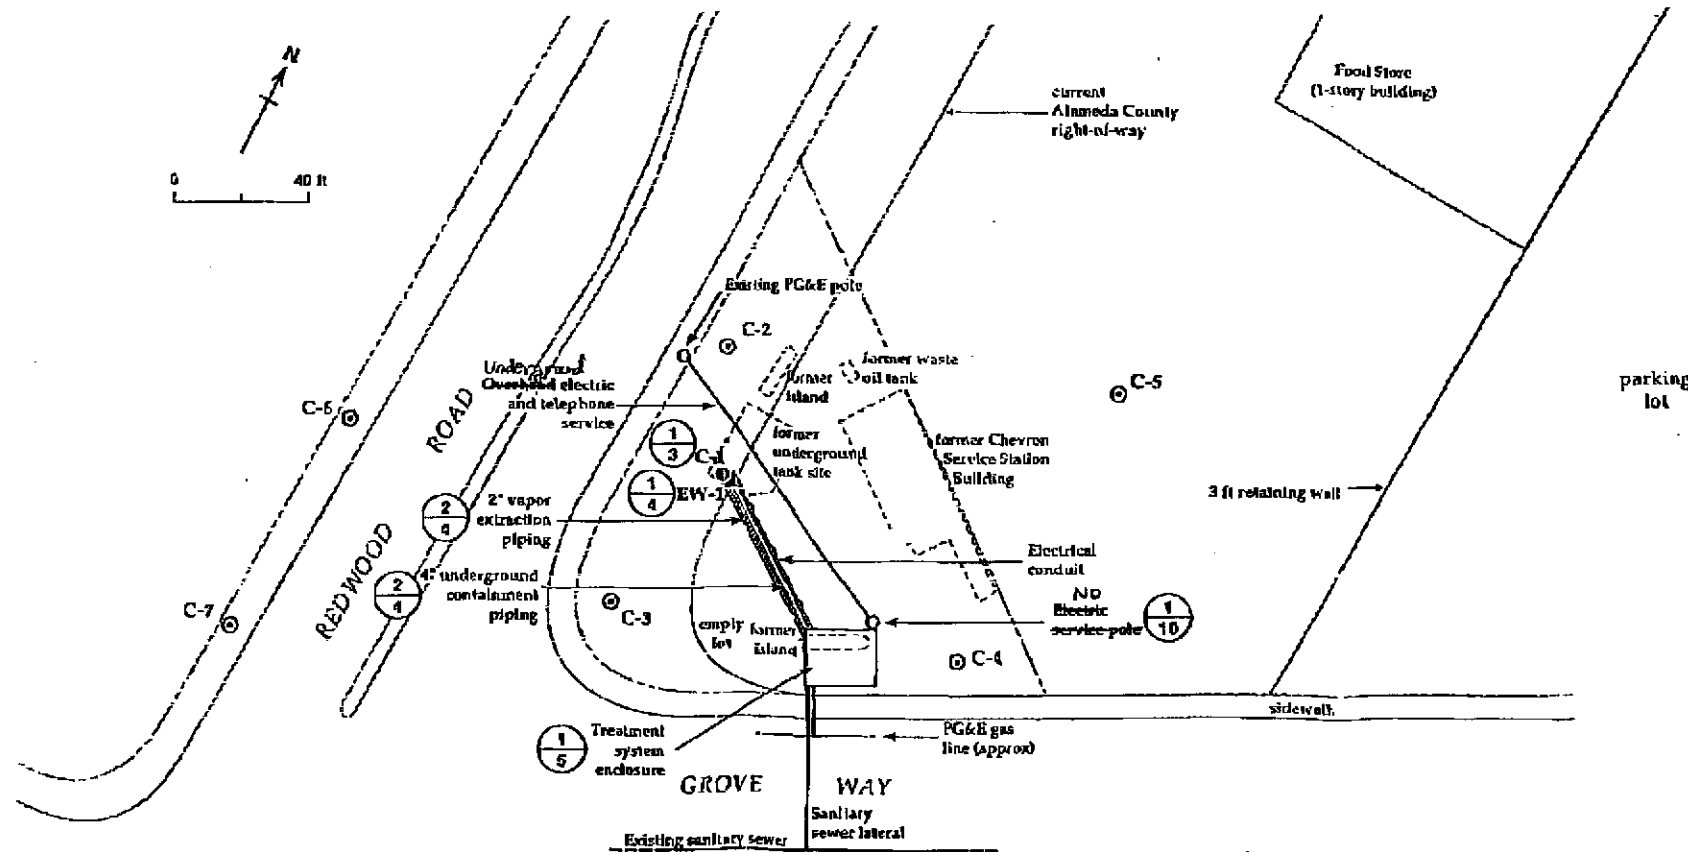

EXPLANATION	
⊙ C-3	Existing monitoring well
⊙ C-1	Existing monitoring well converted to soil vapor extraction well
▲ EW-1	Proposed ground water extraction well

	BY	DATE	REV.	DESCRIPTION	DATE	APP'D
DRAWN	SB	7/1/92				
DESIGNED						
CHECKED	SB	7/1/92				
APPROVED						

PROJ. NO. 4-152

GROUND WATER REMEDIATION SYSTEM


SITE PLAN AND WELL LOCATIONS

Sheets No. **2**
OF 11 SHEETS

Chevron Service Station #5-2968
2816 Grove Way, Castro Valley, California


1
5

TREATMENT SYSTEM ENCLOSURE PLAN VIEW

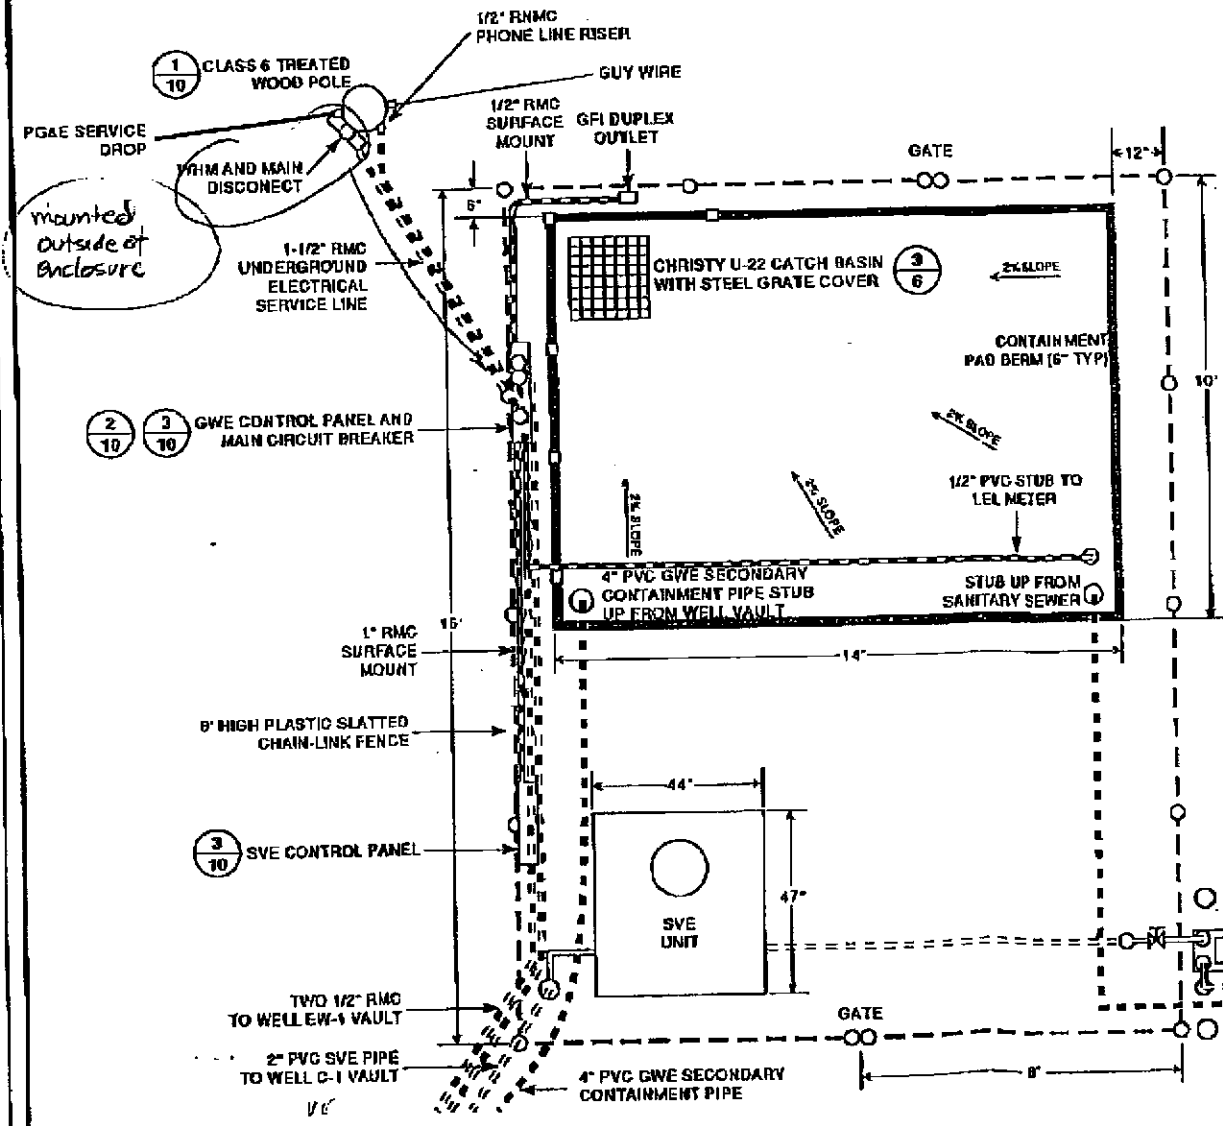

2
5

GROUND WATER TREATMENT SYSTEM LAYOUT

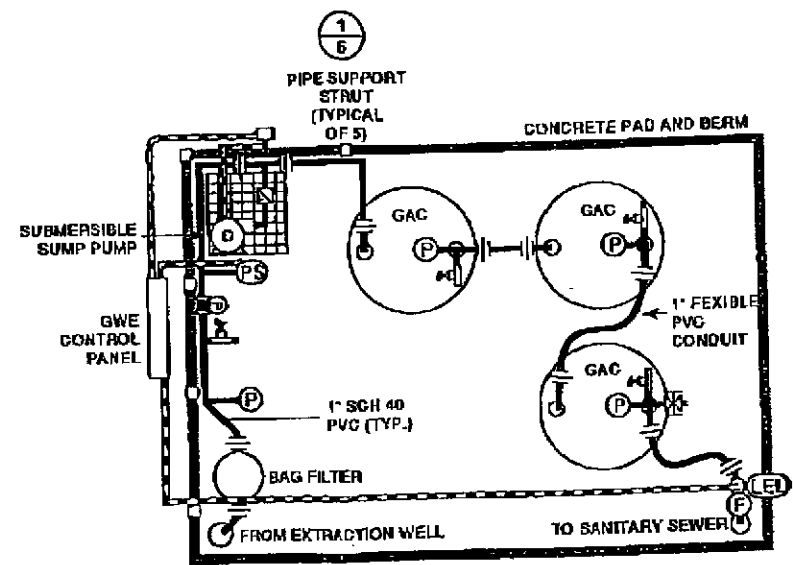


NOT TO SCALE

	BY	DATE	REV.	DESCRIPTION	DATE	APP'D
DRAWN	SD	7/1/97				
DESIGNED						
CHECKED	WES	7/1/97				
APPROVED						


PROJ. NO. 4-552
**GROUND WATER REMEDIATION SYSTEM
 TREATMENT SYSTEM PAD AND
 GROUND WATER TREATMENT
 SYSTEM LAYOUT**
 Chevron Service Station #9-2960
 2816 Grove Way, Castro Valley, California

SHEET NO.
5
OF 12 SHEETS


1 11 EQUIPMENT ENCLOSURE FRONT VIEW (WEST)

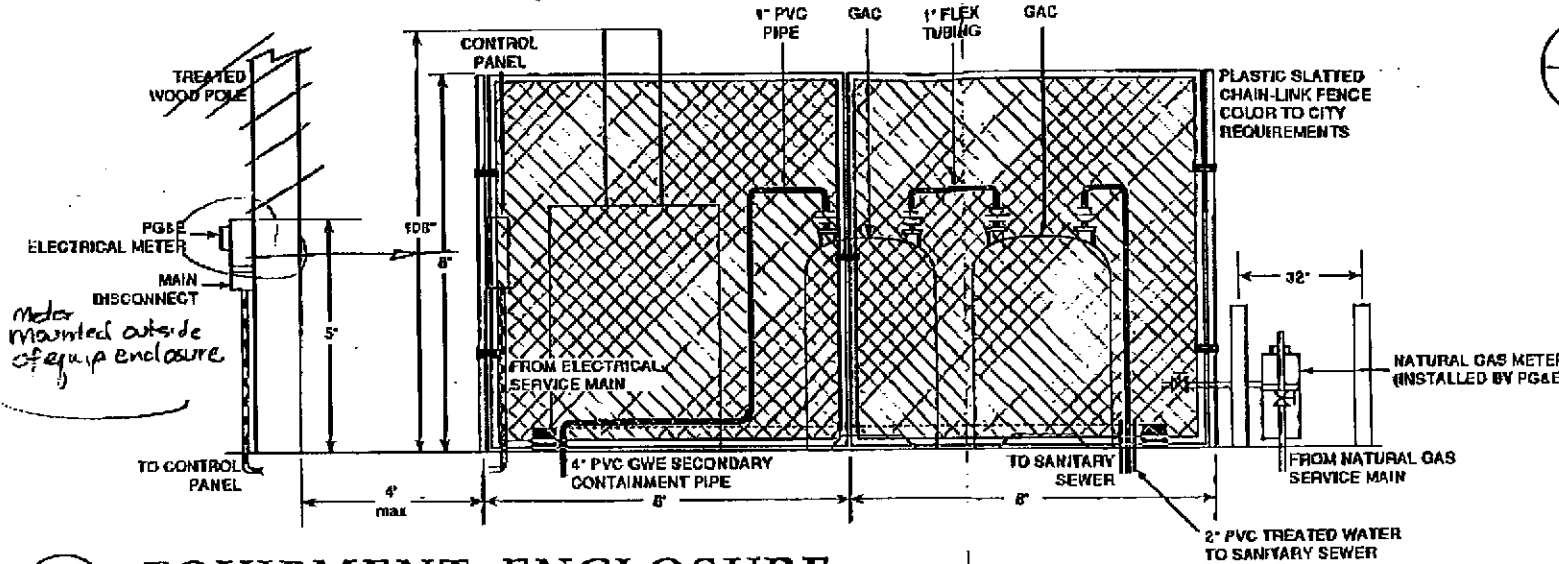

3 11 CRASH POST DETAIL

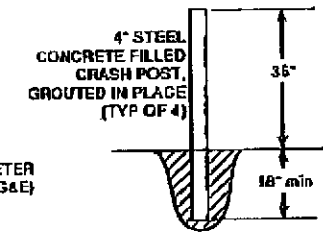

2 11 EQUIPMENT ENCLOSURE SIDE VIEW (SOUTH)

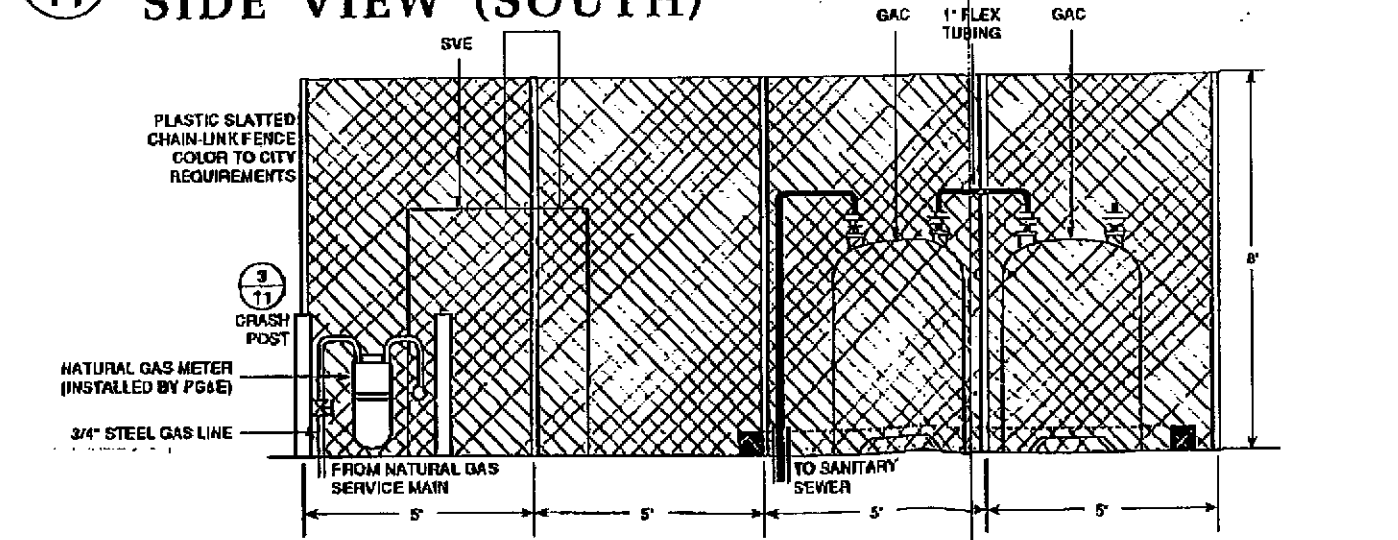

NOT TO SCALE

DRAWN	BY	DATE	REV.	DESCRIPTION	DATE	APP'D
	SE	7/1/92				
DESIGNED						
CHECKED	EB	7/1/92				
APPROVED						

PROJ. NO. 4-352
GROUND WATER REMEDIATION SYSTEM
EQUIPMENT ENCLOSURE
Chevron Service Station #9-2960
2116 Green Hwy, Castro Valley, California

SHEET NO.
11
OF 13 SHEETS.