

EXTENSIVE FIELD WORK NOTICE

TO: _____

DATE: 12/17/2014 _____

Kevin Schinmann, 7-Eleven, Inc., Market Manager (2369)	kevin.schinmann@7-11.com
Amy Zuras, Field Consultant	amy.zuras@7-11.com
Jose Rios, 7-Eleven, Inc., MES	jose.rios@7-11.com
John Wainwright, Stantec, RSPM	john.wainwright@stantec.com
Terry Truax, 7-Eleven, Inc., RPM	terence.truax@7-11.com
Olan Smith, 7-Eleven, Inc., DFM	olan.smith@7-11.com
Jay Stemley, FM Facilities Management	jay.stemley@fmFacilityMaintenance.com
Stephen Boyd, 7-Eleven, Inc., RGECEM	stephen.boyd@7-11.com
Deanne Rotta, 7-Eleven, Inc., RGECS	deanne.rotta@7-11.com
Jerry Wickham, ACEH	jerry.wickham@acgov.org
Kanwar Singh, Franchisee	(925) 606-7751

RE: 7-Eleven Store Number: **32266 (Market 2369)**
Site Address: 1339 North Vasco Road
Livermore, California

Field Activities: **Groundwater monitoring well destruction**

Dear All:


This serves as notification that destruction of five groundwater monitoring wells (MW-1 through MW-5) at the above referenced 7-Eleven Store #32266 is scheduled to begin on **Tuesday, January 6, 2015**. This work is being conducted in order to comply with the environmental case closure as directed by the Alameda County Environmental Health (ACEH). It is anticipated that the onsite portions of the well destructions will be completed within three (3) business days. The removal activities **will not** impede store operations and the site **will remain accessible** for guests. The central northern dispenser may be blocked for a short period of time during the destruction of MW-2.

Any debris generated during this scope of work will be temporarily stored in 55-gallon drums pending removal for disposal within two weeks of the completion of the destruction activities.

Sincerely,


Stantec Consulting Services Inc.

Danielle Manning
Project Manager
Stantec Consulting Services Inc.
Ph: (916) 384-0706
Fx: (916) 861-0430
Cell: (916) 281-4942
Danielle.manning@stantec.com

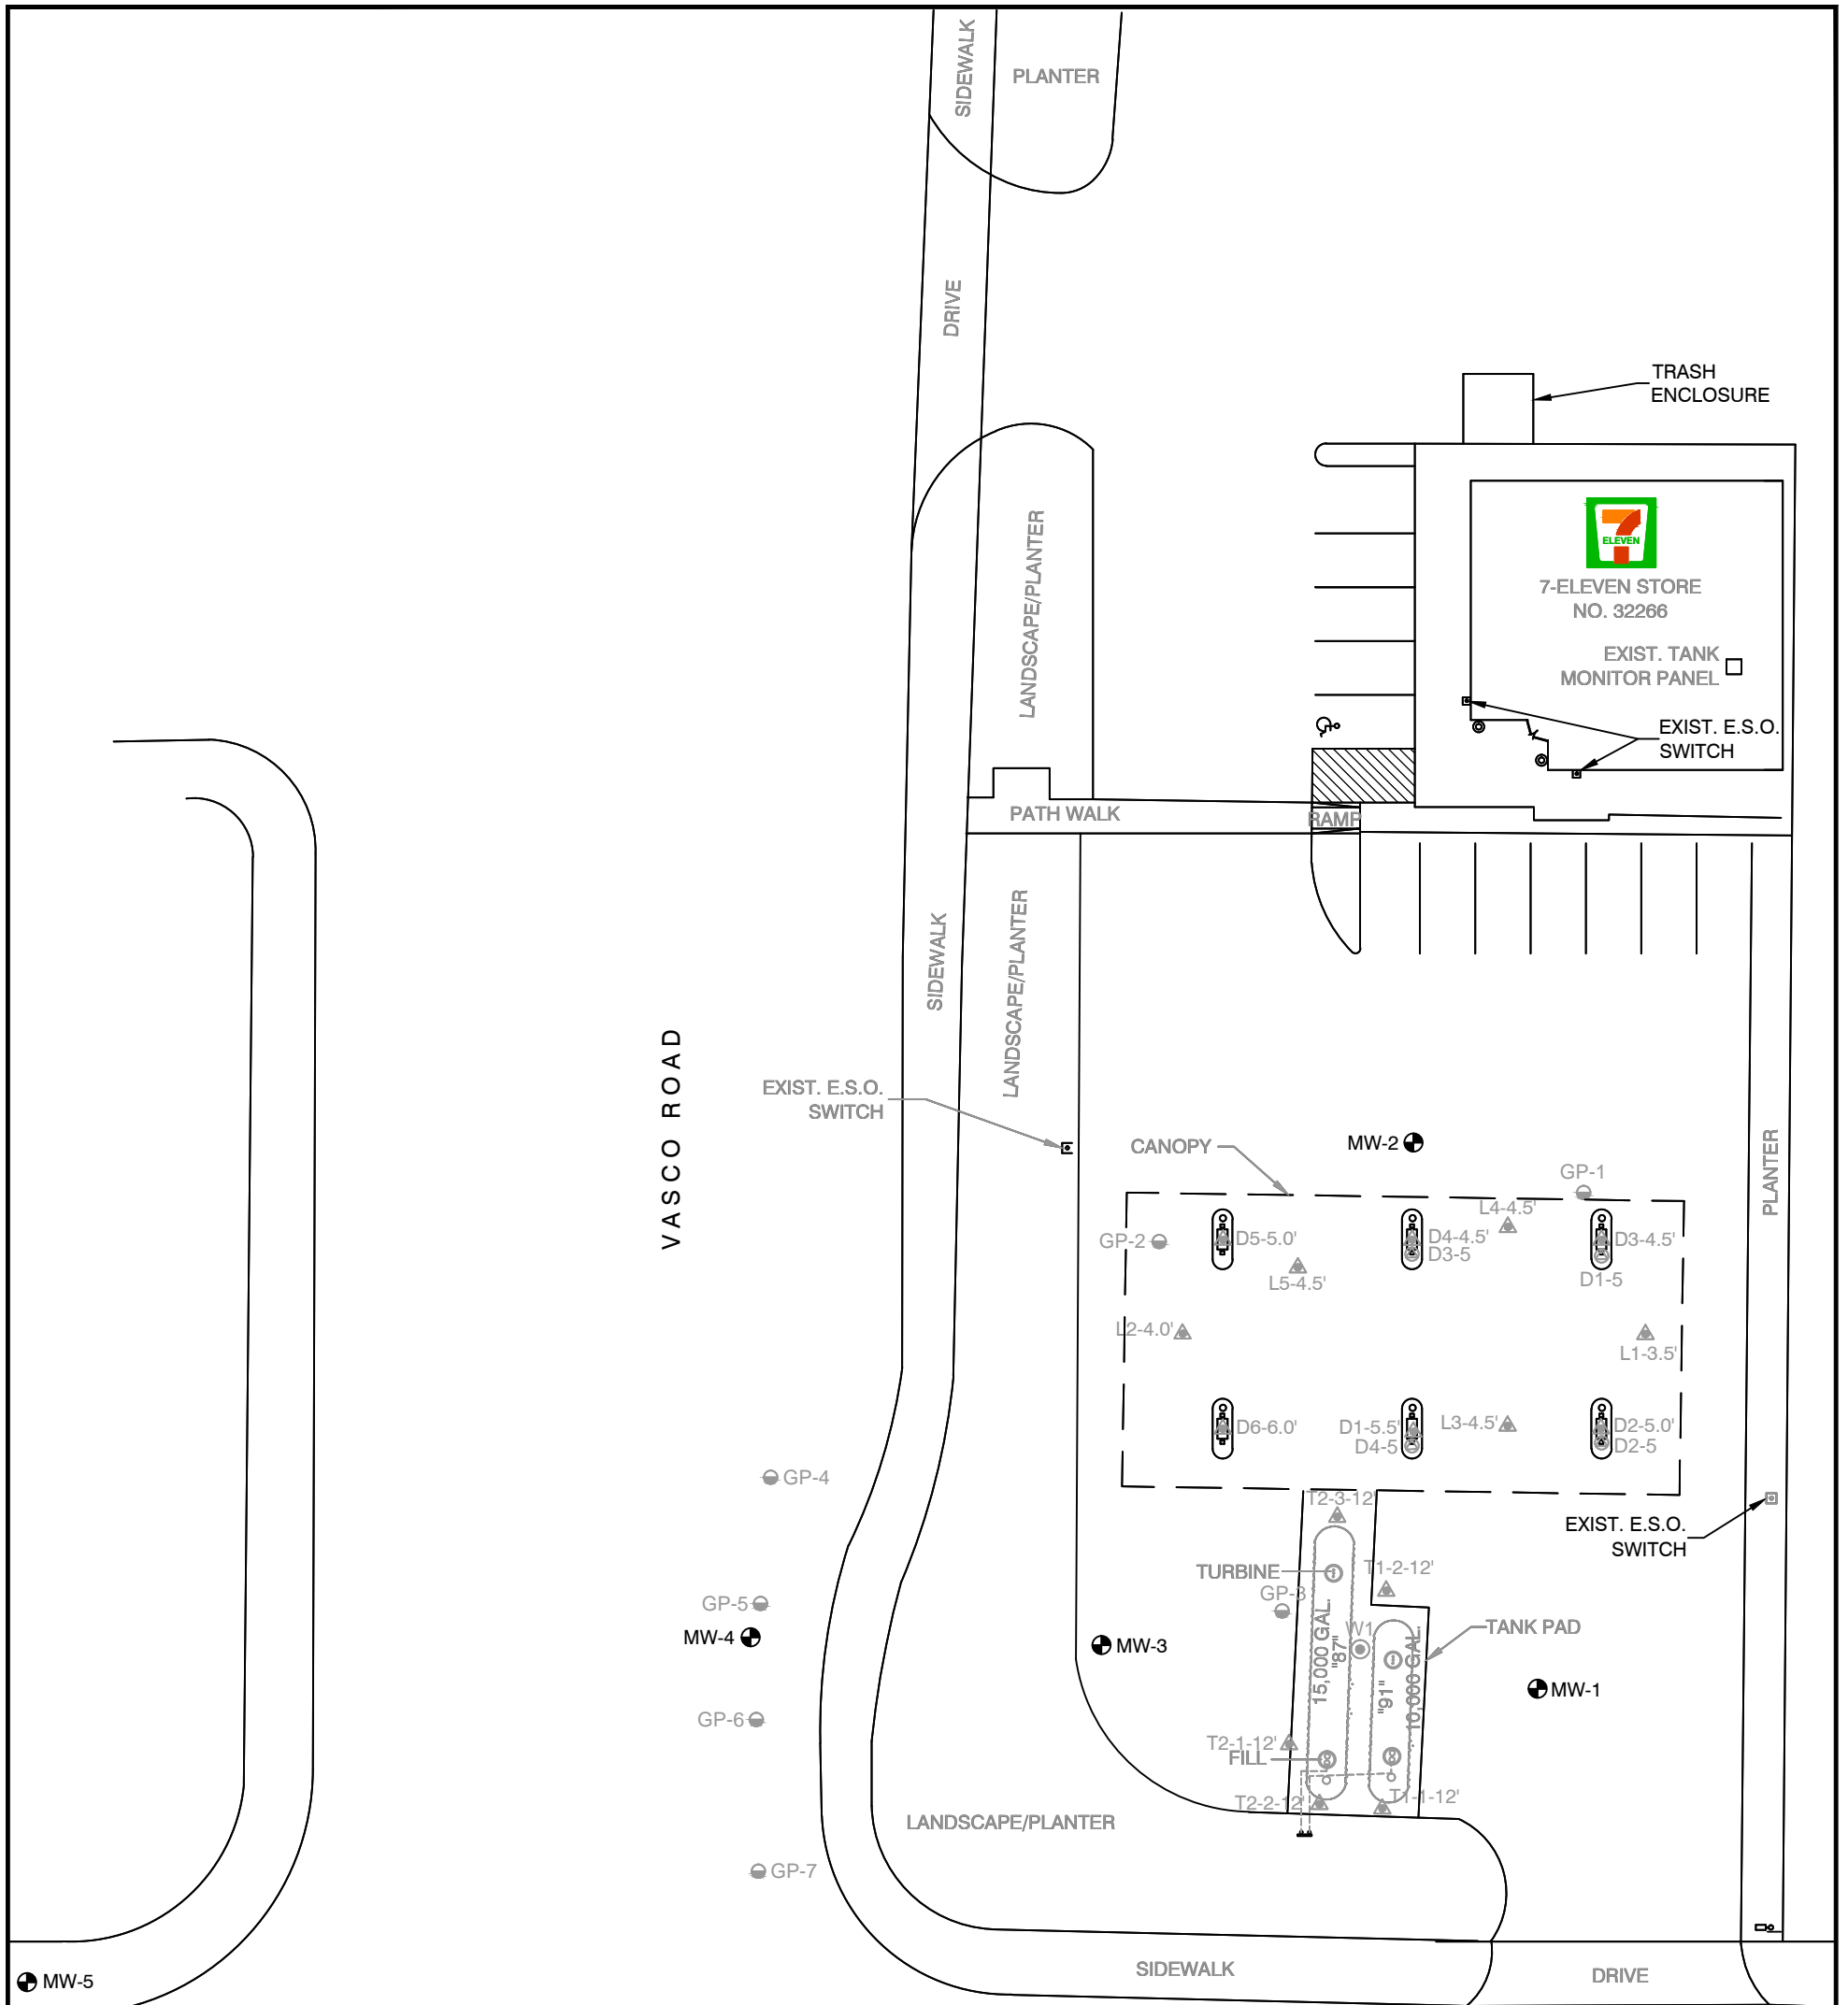

LEGEND:

- MW-1 ● GROUNDWATER MONITORING WELL
- W1 ● UST EXCAVATION WATER SAMPLE LOCATION
- GP-1 ● GEOPROBE SAMPLE LOCATION
- L5-4.5' ▲ 2005 SOIL SAMPLE LOCATION
- D1-5 ● 2008 SOIL SAMPLE LOCATION

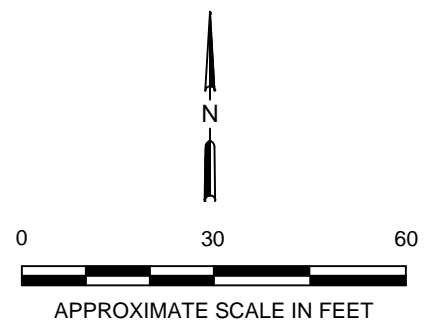

REFERENCE: THIS FIGURE IS BASED ON AN AERIAL SURVEY PROVIDED BY STANTEC CONSULTING SURVEYING GROUP

No warranty is made by Stantec Consulting Services Inc. as to the accuracy, reliability, or completeness of these data. Original data were compiled from various sources. This information may not meet National Map Accuracy Standards. This product was developed electronically, and may be updated without notification. Any reproduction may result in a loss of scale and/or information.

	FOR: STORE NO. 32266 1339 NORTH VASCO ROAD LIVERMORE, CALIFORNIA	SITE PLAN		FIGURE: 2
	JOB NUMBER: 185750084	DRAWN BY: STA	CHECKED BY: ASM	APPROVED BY: ASM